



City of Fitchburg
Planning/Zoning Department
5520 Lacy Road
Fitchburg, WI 53711
(608-270-4200)

ARCHITECTURAL & DESIGN REVIEW APPLICATION

Applicant/Contact Person: Andrew Weiland

Address: 123 East Grove Street

Phone Number of Contact Person: 608-729-5958

City, State, Zip Code: Oregon, WI 53575

Email of Contact Person: atw@oregonsd.net

Project Address: Brassica Road

Lot: 1

Subdivision: Terravessa

Project Type: ☐ Multi-Family ☒ Commercial ☐ Industrial ☐ Other
☒ New ☐ Addition

Impervious Surface Ratio (ISR): 52.3 (City Standard: maximum 65% ISR)

All items listed below must be included with the application to be considered complete. If an item is not included with the application, the applicant must provide in writing the basis for not including it. Building and site plans submitted to the Fitchburg Plan Commission for architectural and design review shall contain the following information:

Site Data:

- ☒ 1. Lot or property dimensions.
- ☒ 2. Orientation (to north).
- ☒ 3. Adjacent highways, roads, drive, etc.
- ☒ 4. Existing natural features (rivers, ponds, wetlands).
- ☒ 5. Existing buildings and/or improvements.
- ☒ 6. Existing and proposed site drainage.
- ☒ 7. Utility plans, including main/lateral sizes and existing fire hydrants on site or within 300 feet of the site
- ☒ 8. ISR shall be indicated on all plans.
- ☒ 9. Stormwater management plans and details, including grading plan.
- ☒ 10. Lighting plan in footcandles and light fixture cut sheets.

Building:

- ☒ 1. Building size, configuration and orientation.
- ☒ 2. Distance from lot lines.
- ☒ 3. Distance from other buildings, improvements and natural features.
- ☒ 4. Location of well, septic tank, drainfield, etc. (if applicable)
- ☒ 5. Additional proposed additions or new structures, including trash/recycling enclosure(s).
- ☒ 6. Construction type (wood frame, structural steel, etc.).
- ☒ 7. Foundation type (full basement, slab on grade, etc.).
- ☒ 8. Number of levels.
- ☒ 9. Siding/exterior covering type, color, texture, etc.
- ☒ 10. Roof type (gable, hip, shed, flat, etc.) and pitch.
- ☒ 11. Roofing material type, color, texture, etc.
- ☒ 12. Exterior door and window location, size, type, etc.
- ☒ 13. Fire protection sprinklers or fire alarm systems.

Ingress, Egress, Parking:

- ☒ 1. Location of highway and road access points.
- ☒ 2. Location, size, configuration of drives and walks.
- ☒ 3. Number, size, location of parking spaces.
- ☒ 4. Location of handicapped parking and accessible building entrances.
- ☒ 5. Bicycle rack(s).



NEW BUILDING:
ELEMENTARY SCHOOL
OREGON SCHOOL DISTRICT
FITCHBURG, WI 53711

CITY SUBMITTAL
OCTOBER 23, 2018



Office Locations:
Milwaukee
829 S. 1st Street
Milwaukee, Wisconsin 53204
T: 414.226.0200
Sheboygan
1227A North 8th Street
PO Box 955
Sheboygan, Wisconsin
53082
T: 920.459.4200
www.brayarch.com

DRAWING INDEX			
BUILDING INFORMATION OREGON ELEMENTARY K-6 SCHOOL PRIMARY OCCUPANCY = E NON-SEPARATED OCCUPANCY = A-2 (CAFETERIA) PER IBC 303.1.3 CONSTRUCTION TYPE = IB STEEL SUPERSTRUCTURE WITH MASONRY AND STEEL STUD INFILL FOUNDATION TYPE = SLAB ON GRADE W/ NO BASEMENT NUMBER OF LEVELS = TWO STORY ROOF TYPE = LOW SLOPE EPDM W/ POLYISO INSULATION ON STEEL DECK FULLY SPRINKLERED BUILDING FIRST FLOOR FOOTPRINT = 93,000 SF			CITY SUBMITTAL A0.0C COVER SHEET CITY SUBMITTAL A0.5C FLOOR PLANS A1.0C EXTERIOR ELEVATIONS A2.0C 3D VIEWS C0.0C LOT INFORMATION C1.0C SITE DEMOLITION PLAN C2.0C SITE LAYOUT PLAN C3.0C GRADING PLAN C4.0C EROSION CONTROL PLAN C5.0C UTILITY PLAN C6.0C SITE DETAILS C6.1C SITE DETAILS E1.0C SITE LIGHTING L1.0C LANDSCAPE PLAN

Project Title:
**NEW BUILDING:
ELEMENTARY SCHOOL
OREGON SCHOOL DISTRICT
FITCHBURG, WI 53711**

REVISIONS:

#	DATE	DESCRIPTION
---	------	-------------

**NOT FOR
CONSTRUCTION**

Project Number:
3322

Issued For:
CITY SUBMITTAL

10/23/2018

Sheet Title:
**COVER SHEET
CITY SUBMITTAL**

Sheet Number:
A0.0C

10/22/2018 4:53:49 PM
B:\367\3322 - Oregon SD Long Range Planning\3322 Oregon Elementary School_Arch R19.rvt



Office Locations:
Milwaukee
829 S. 1st Street
Milwaukee, Wisconsin 53204
T: 414.226.0200
Sheboygan
1227A North 8th Street
PO Box 955
Sheboygan, Wisconsin
53082
T: 920.459.4200
www.brayarch.com

Project Title:
**NEW BUILDING:
ELEMENTARY SCHOOL
OREGON SCHOOL DISTRICT
FITCHBURG, WI 53711**

REVISIONS:
DATE DESCRIPTION

**NOT FOR
CONSTRUCTION**

Project Number:
3322

Issued For:

CITY SUBMITTAL

10/23/2018


Sheet Title:
FLOOR PLANS

Sheet Number:

A0.5C


KEYNOTE LEGEND

E2	ZINC STANDING SEAM PANEL - SIMILAR TO RHEINZINK ANGLED STANDING SEAM SYSTEM
E3	ZINC RAINSCREEN SYSTEM
E4	ZINC STANDING SEAM PANEL - SIMILAR TO RHEINZINK ANGLED STANDING SEAM SYSTEM - ALTERNATIVE COLOR
E5	STOREFRONT SYSTEM
E6	CURTAINWALL SYSTEM
E7	FIBER CEMENT RAINSCREEN SYSTEM
E8	FIBER CEMENT ACCENT PANEL
E9	MASONRY STONE VENEER

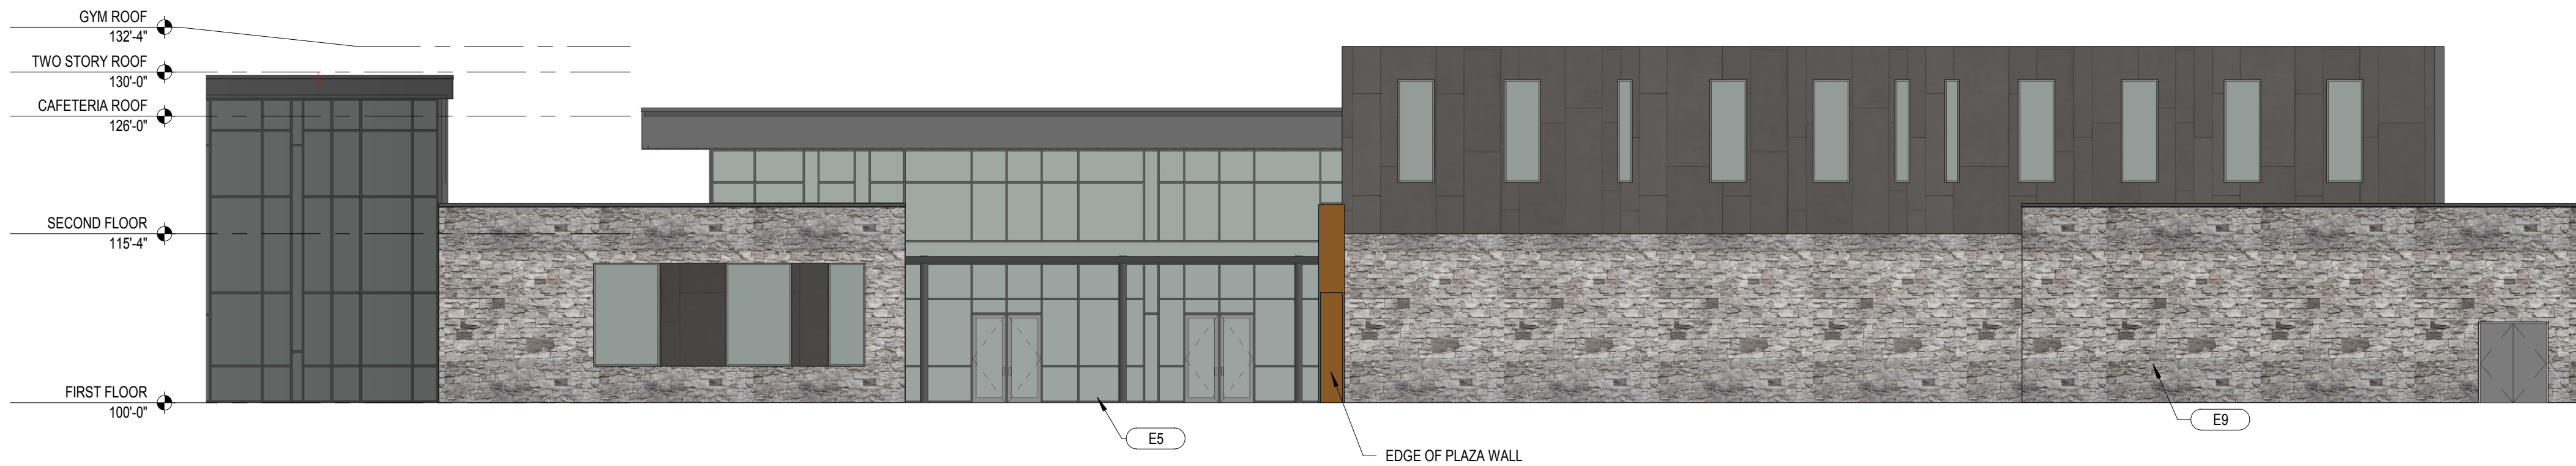

5 CITY SUB CAFETERIA/GYM NORTH

A1.0 Scale: 3/32" = 1'-0"

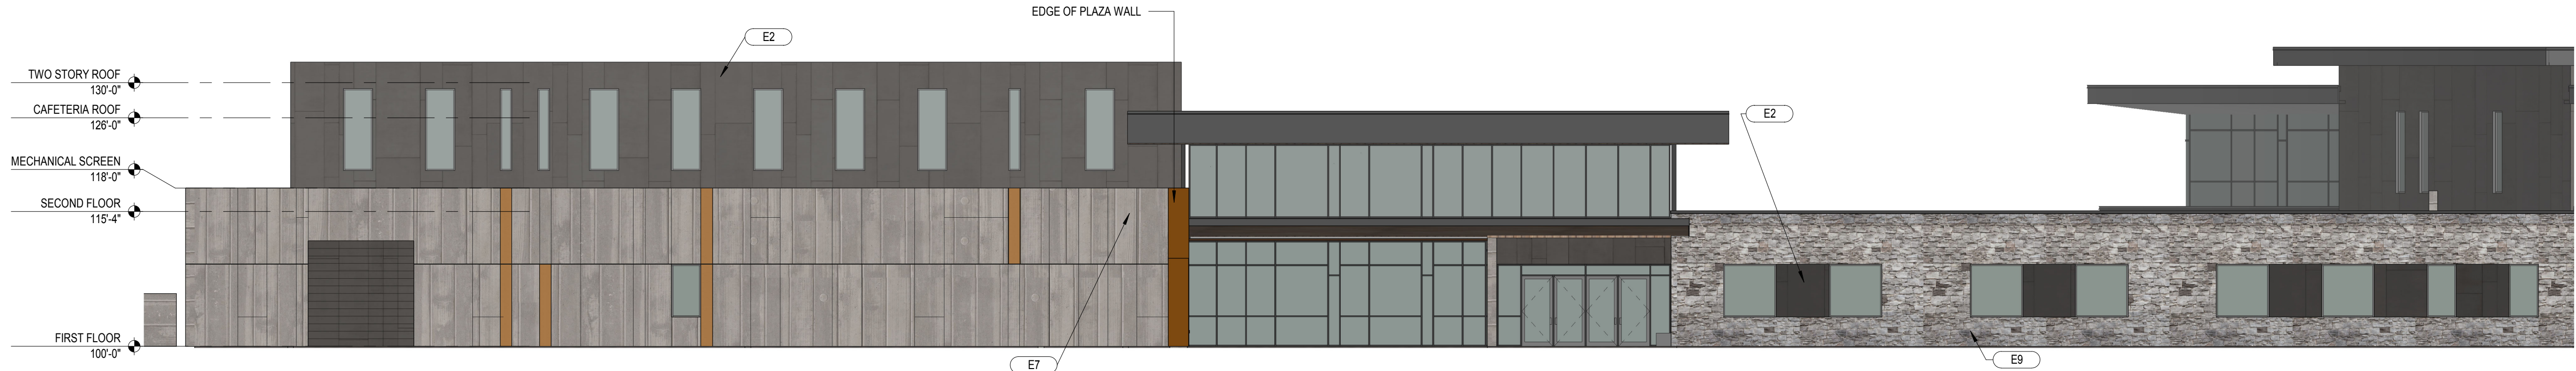


4 MAIN ENTRY_CITY SUBMITTAL

A1.0 Scale: 3/32" = 1'-0"



3 NORTH CLASSROOM ELEVATION_CITY SUBMITTAL

A1.0 Scale: 3/32" = 1'-0"

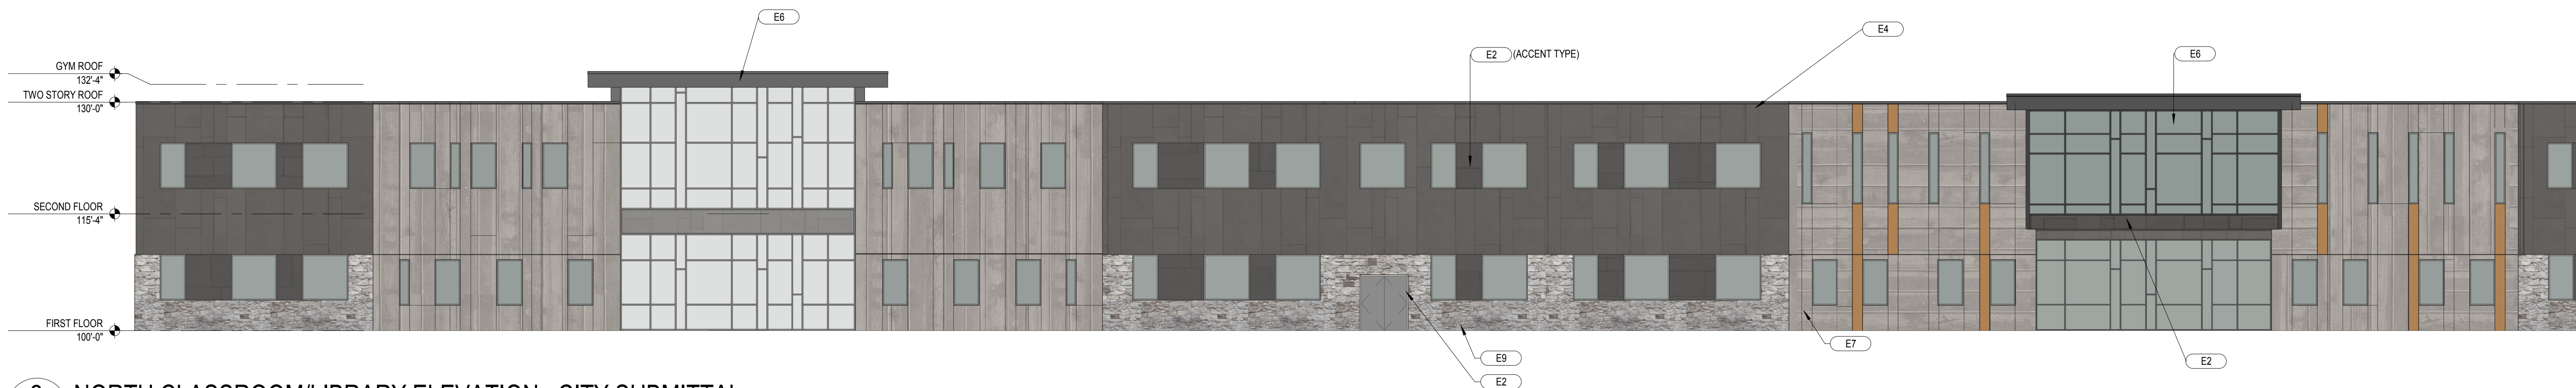

2 NORTH CLASSROOM/LIBRARY ELEVATION_CITY SUBMITTAL

A1.0 Scale: 3/32" = 1'-0"



1 MUSIC/SCIENCE EAST_CITY SUBMITTAL

A1.0 Scale: 3/32" = 1'-0"

Office Locations:

Milwaukee
829 S. 1st Street
Milwaukee, Wisconsin 53204
T: 414.226.0200

Sheboygan
1227A North 8th Street
PO Box 955
Sheboygan, Wisconsin
53082
T: 920.459.4200
www.brayarch.com

Project Title:
**NEW BUILDING:
ELEMENTARY SCHOOL
OREGON SCHOOL DISTRICT
FITCHBURG, WI 53711**

REVISIONS:
DATE DESCRIPTION

**NOT FOR
CONSTRUCTION**

Project Number:
3322

Issued For:
CITY SUBMITTAL

10/23/2018

Sheet Title:
**EXTERIOR
ELEVATIONS-CITY
OF FITCHBURG**

Sheet Number:

A1.0C

10/23/2018 8:56:00 AM
B:\362\332 - Oregon SD Long Range Planning\332 Oregon Elementary School_Arch R19.rvt



Sheet Number:
A2.0CS

Sheet Title:
3D VIEWS

10/23/2018

CITY SUBMITTAL

Issued For:

Project Number:
3322

**NOT FOR
CONSTRUCTION**

REVISIONS:

NO.	DATE	DESCRIPTION
-----	------	-------------

Project Title:
**NEW BUILDING:
OREGON SCHOOL DISTRICT
FITCHBURG, WI 53711**

Office Locations:

Milwaukee
829 S. 1st Street
Milwaukee, Wisconsin 53204
T: 414.226.0200

Sheboygan
1227A North 8th Street
PO Box 955
Sheboygan, Wisconsin
53082
T: 920.459.4200
www.brayarch.com



bray
architects
solid foundation. forward thinking.

0.81 Ac*

LOT 1
11.28 Ac.

Outlot 1
12.65 Ac.

SORREL RD


CTH MM

BRASSICA ROAD

RADIOCHIO DRIVE

C0.0

*0.81 Ac. included in
Outlot 1 area

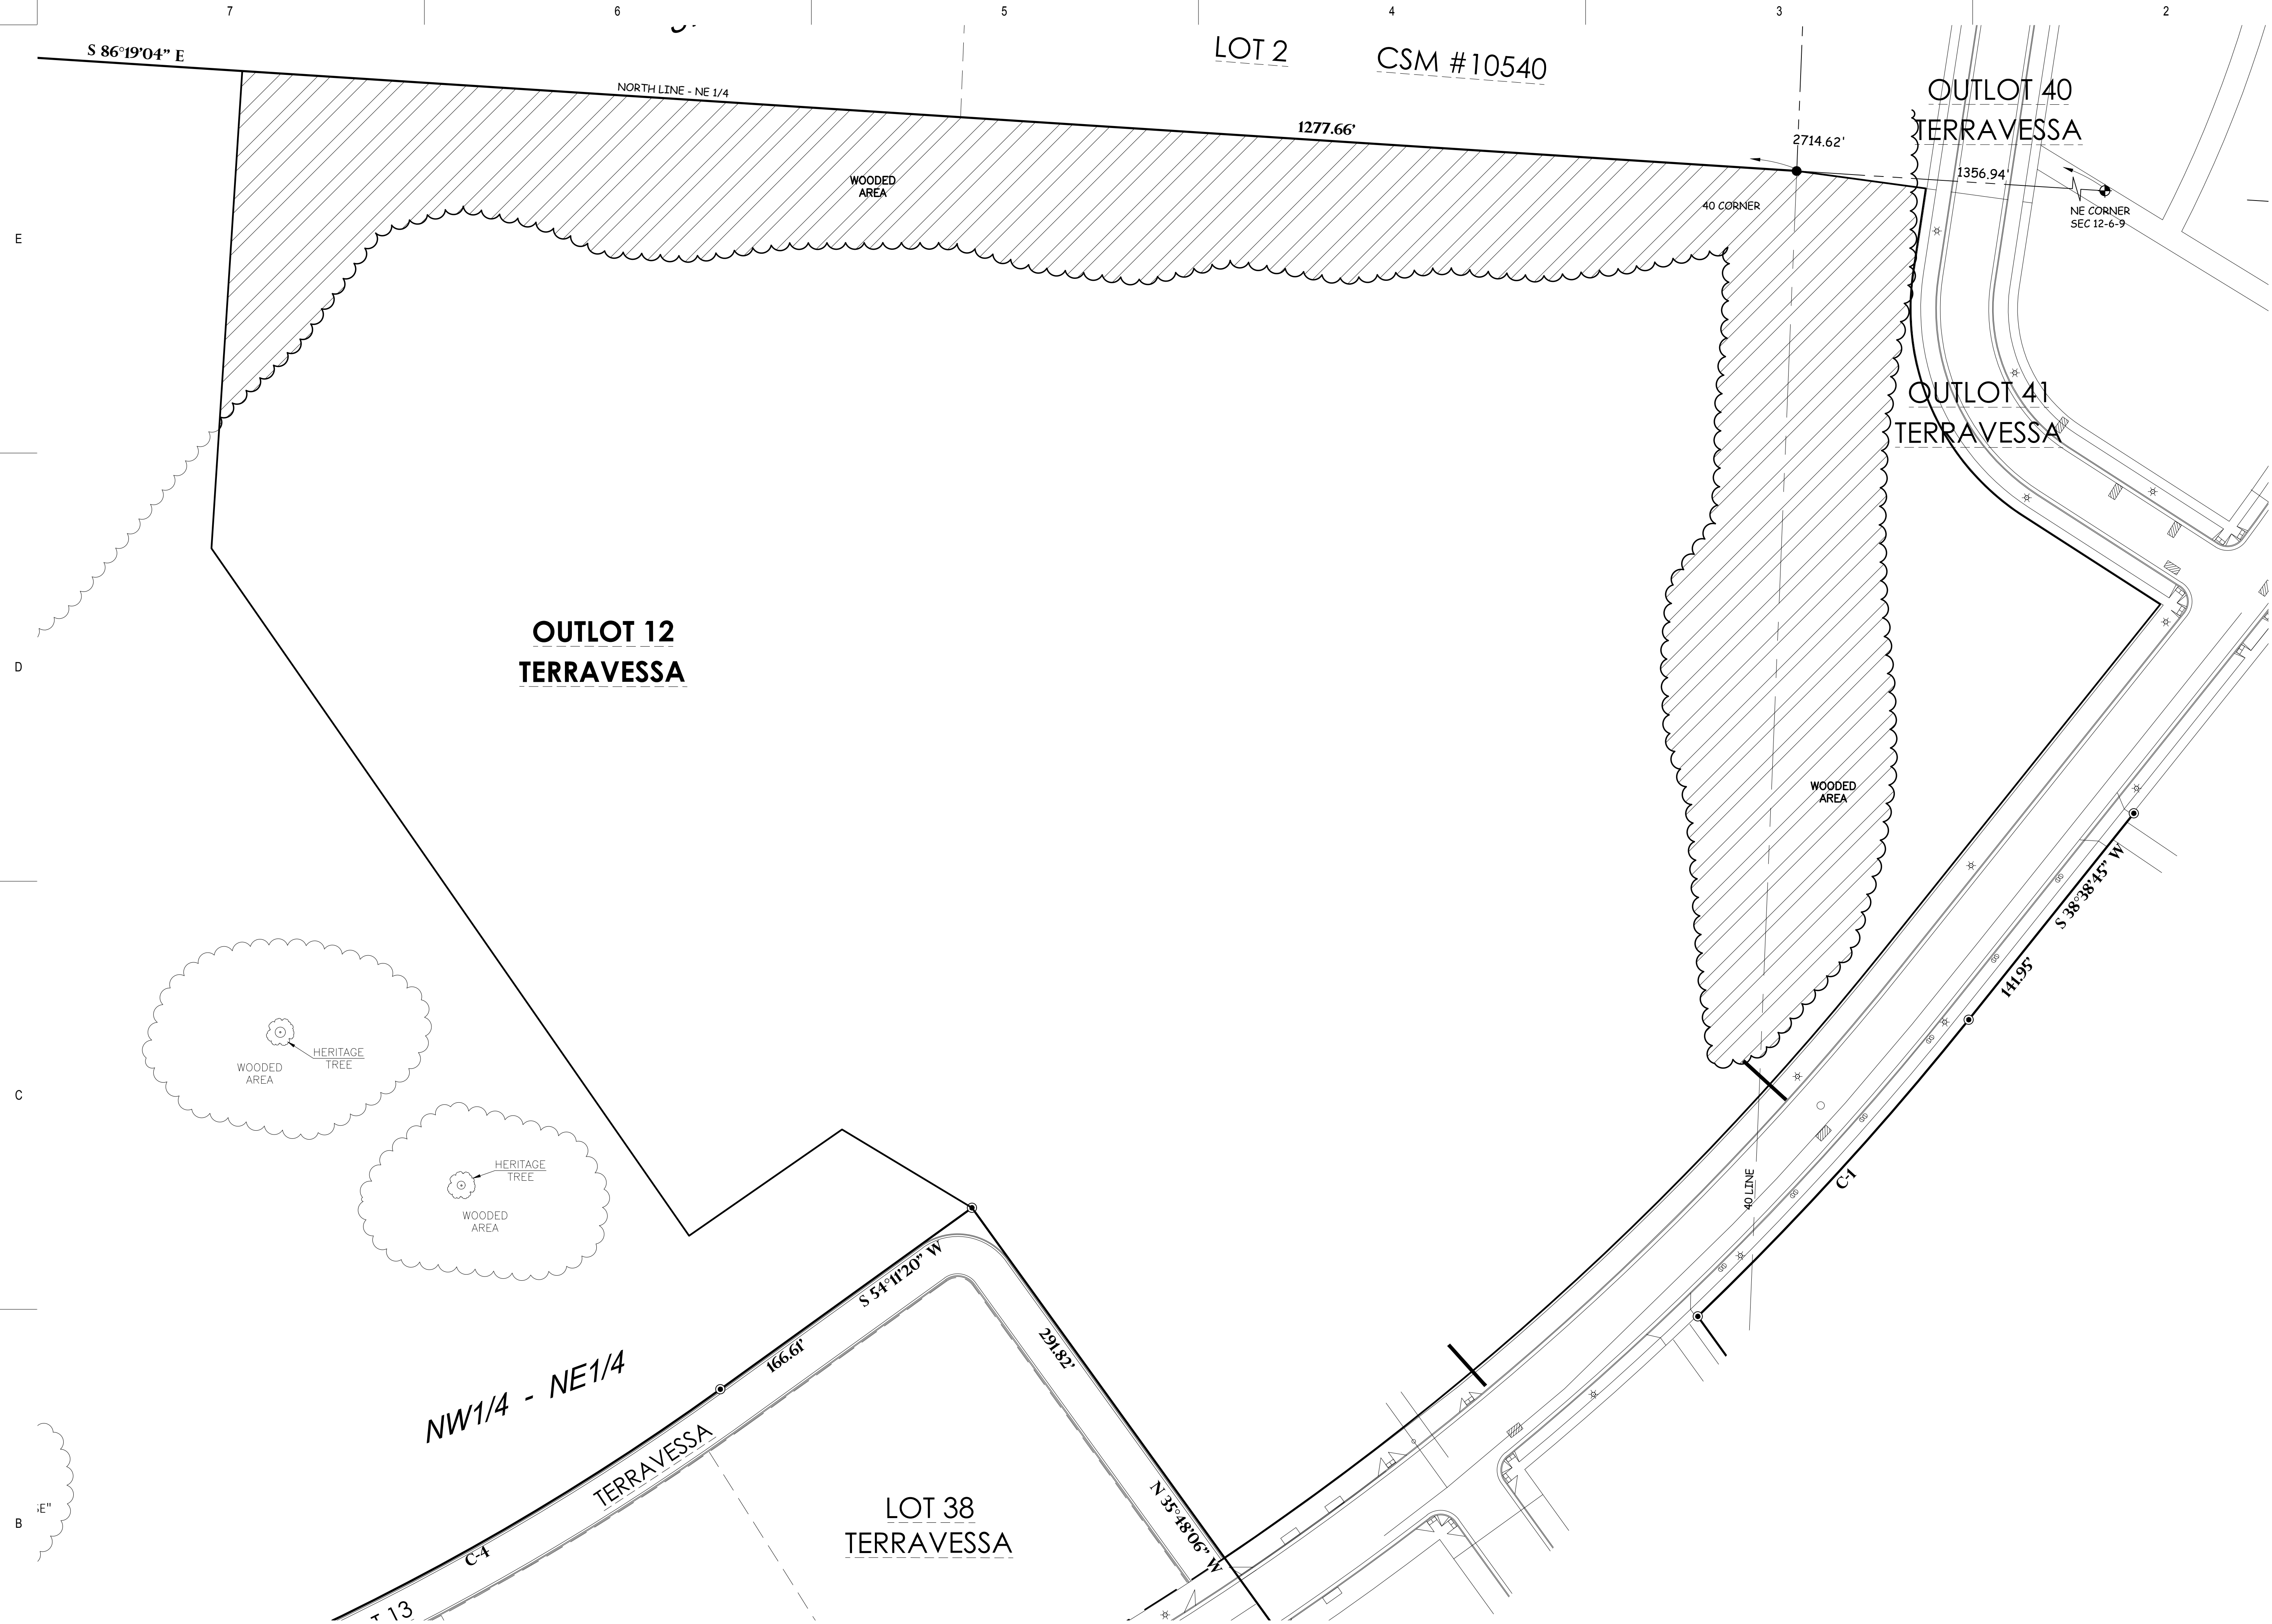


GENERAL NOTES:

1. CONTACT DIGGER'S HOTLINE 5 WORKING DAYS PRIOR TO THE START OF DEMOLITION/CONSTRUCTION.
2. ALL DEMOLITION MATERIALS SHALL BE REMOVED FROM THE SITE AND DISPOSED OF IN A LEGAL MANNER EXCEPT FOR THOSE ITEMS NOTED TO BE SALVAGED, WHICH SHOULD BE TURNED OVER TO THE OWNER.
3. INSTALL AND MAINTAIN ALL REQUIRED EROSION CONTROL MEASURES FOR PERIMETER PROTECTION PRIOR TO THE START OF DEMOLITION/CONSTRUCTION, IN ACCORDANCE WITH THE LOCAL AND STATE GOVERNING AUTHORITIES.
4. ALL BIDDERS SHALL VISIT THE SITE AND REVIEW EXISTING CONDITIONS PRIOR TO SUBMITTING A BID.
5. COORDINATE WITH THE OWNER AND LOCAL UTILITY COMPANIES TO LOCATE ANY EXISTING UTILITIES ON SITE PRIOR TO THE START OF WORK.
6. ANY EXISTING UTILITIES NOT SHOWN ON THIS DOCUMENT WHICH NEED TO BE REMOVED, RELOCATED OR ADJUSTED SHALL BE THE RESPONSIBILITY OF THE SITE GRADING CONTRACTOR AND INCLUDED IN THE BASE BID CONTRACT.
7. STRIP TOPSOIL WITHIN THE PROJECT LIMITS IN ACCORDANCE WITH THE PROJECT MANUAL SPECIFICATIONS.
8. IF STRIPPED TOPSOIL IS STOCKPILED ON SITE, SILT FENCE SHALL BE INSTALLED AROUND THE BASE OF THE STOCKPILE TO PREVENT SEDIMENT TRANSPORT.
9. PRIOR TO PERFORMING WORK WITHIN PUBLIC RIGHT OF WAYS, NOTIFY AND COORDINATE WORK WITH THE LOCAL MUNICIPALITY.
10. MAINTAIN TRAFFIC CIRCULATION TO ALL RETAIL AND COMMERCIAL BUILDINGS SHOWN ON THIS DOCUMENT. COORDINATE ALL WORK WITH SAID BUSINESSES.

DEMOLITION HATCH PATTERNS:

 CLEAR AND GRUB EXISTING
WOODED AREA



BENCH MARK

ELEVATIONS ARE REFERENCED TO NAVD 88 DATUM.


BENCHMARK #1
604 SPIKE IN POWER POLE, LOCATED ON THE EAST SIDE OF C.T.H. "MM" AND BEING APPROXIMATELY 500 FEET SOUTH OF THE NORTHWEST CORNER OF THE SUBJECT PROPERTY.
ELEVATION = 940.78

BENCHMARK #2
604 SPIKE IN POWER POLE, LOCATED ON THE WEST SIDE OF C.T.H. "MM" AND BEING APPROXIMATELY 500 SOUTH OF BENCHMARK #1.
ELEVATION = 913.64

DESCRIPTION

BEING PART OF OUTLOT 12 OF TERRAVESSA, LOCATED IN PART OF THE NORTHWEST 1/4 OF THE NORTHEAST 1/4 OF SECTION 12, TOWNSHIP 6 NORTH, RANGE 9 EAST, CITY OF FITCHBURG, DANE COUNTY, WISCONSIN.

SUBJECT TO (IF ANY) COVENANTS, CONDITIONS, RESTRICTIONS, RIGHT-OF-WAYS AND EASEMENTS OF RECORD.

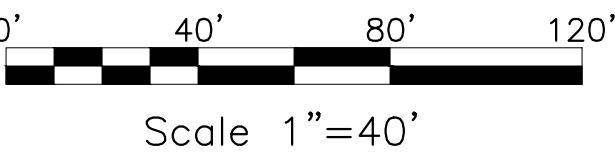

Office Locations:

Milwaukee
829 S. 1st Street
Milwaukee, Wisconsin 53204
T: 414.226.0200

Sheboygan
1227A North 8th Street
PO Box 955
Sheboygan, Wisconsin
53082
T: 920.459.4200
www.brayarch.com

Civil Engineering
Land Surveying
Landscape Architecture

5709 Wincy Drive, Suite D
Stevens Point, WI 54482
715.341.5777 (cell) 715.344.4922 (fax)

POB
Point of Beginning

Project Title:
**NEW BUILDING:
OREGON ELEMENTARY SCHOOL
OREGON SCHOOL DISTRICT
FITCHBURG, WI 53711**

REVISIONS:		
DATE	DESCRIPTION	

**NOT FOR
CONSTRUCTION**


Project Number:
3322

Issued For:
**DESIGN
PROGRESS**

10/18/2018

Sheet Title:
**DEMOLITION
PLAN**

Sheet Number:
C1.0

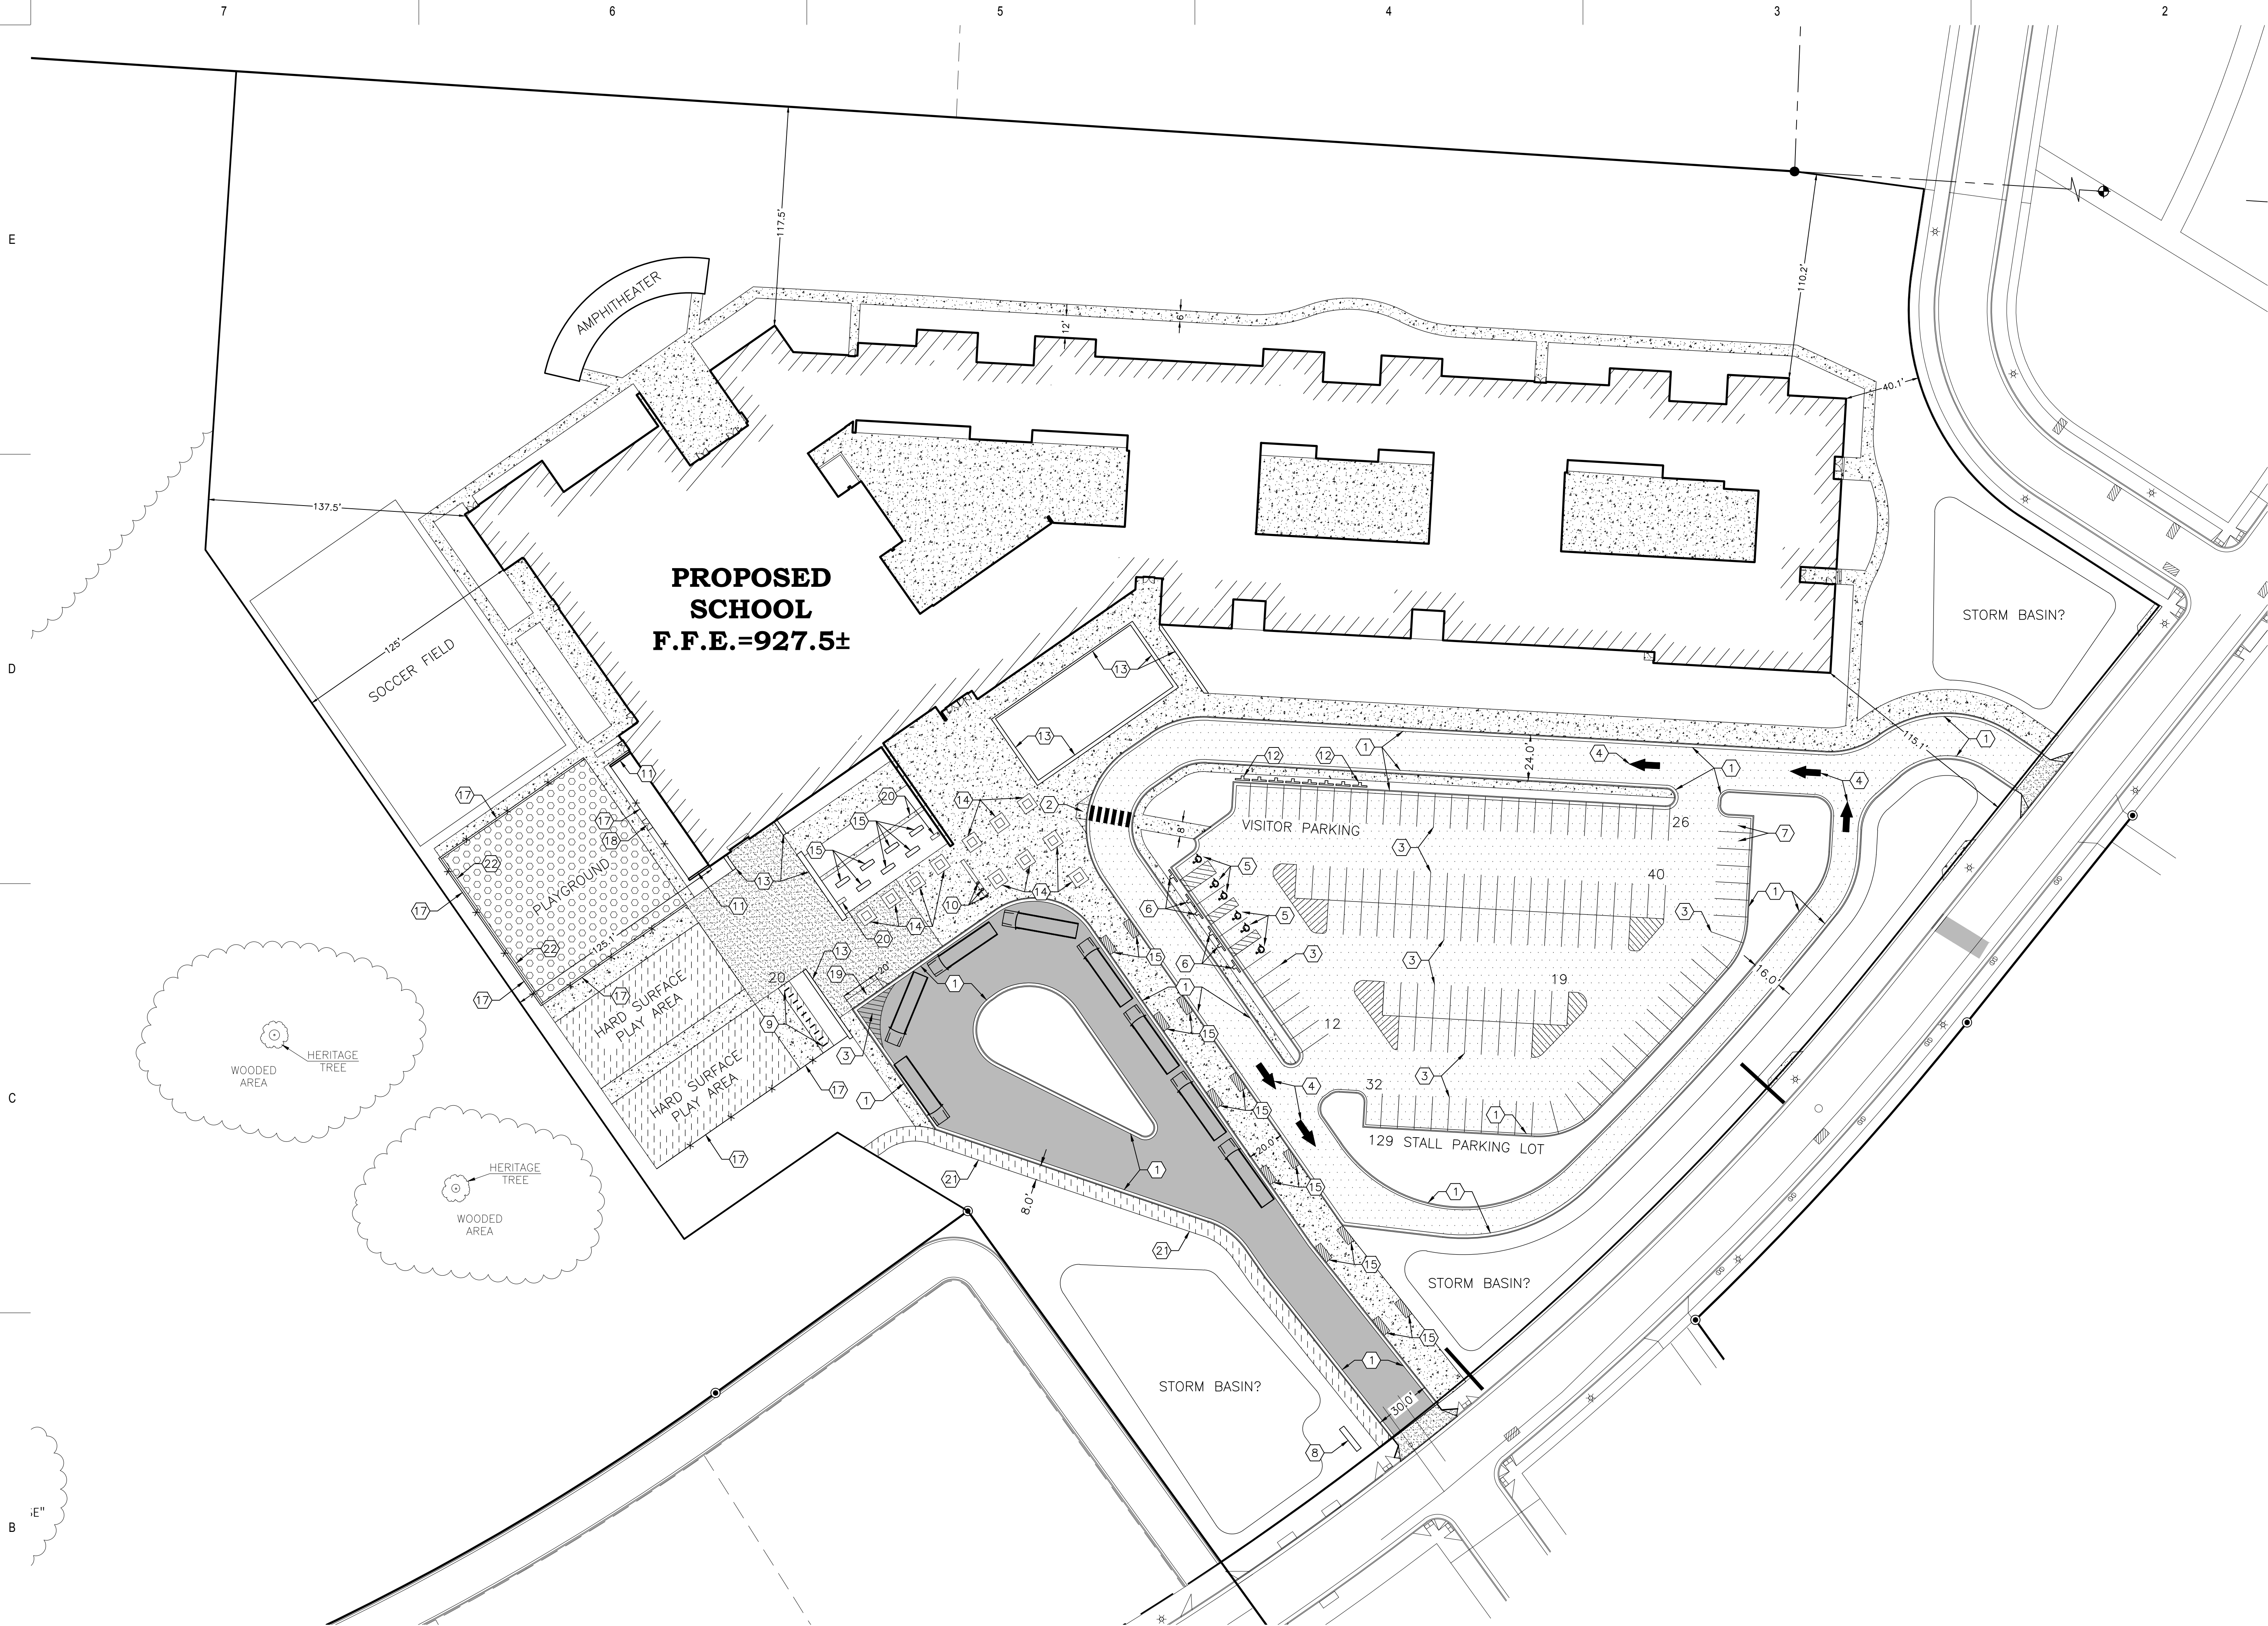

GENERAL NOTES:

- CONTACT DIGGER'S HOTLINE 5 WORKING DAYS PRIOR TO THE START OF DEMOLITION/CONSTRUCTION.
- GRADE, LINE, AND LEVEL TO BE REVIEWED IN THE FIELD BY THE CONSTRUCTION MANAGER.
- ALL REQUIRED EROSION CONTROL MEASURES ARE TO BE INSTALLED AND MAINTAINED IN ACCORDANCE WITH LOCAL MUNICIPAL AND DEPARTMENT OF NATURAL RESOURCES REGULATIONS.
- SEE SHEET C4.0 FOR ALL REQUIRED EROSION CONTROL ELEMENTS.
- ANY EXISTING UTILITIES NOT SHOWN ON THIS DOCUMENT WHICH NEED TO BE REMOVED, RELOCATED AND OR ADJUSTED SHALL BE THE RESPONSIBILITY OF THE SITE GRADING CONTRACTOR AND INCLUDED IN THE BASE BID CONTRACT.
- VERIFY THE LOCATION OF ALL EXISTING UTILITIES PRIOR TO THE START OF DEMOLITION/CONSTRUCTION.
- ALL BIDDERS SHALL VISIT THE SITE AND REVIEW EXISTING CONDITIONS PRIOR TO SUBMITTING A BID.
- PRIOR TO THE START OF WORK VERIFY WITH THE LOCAL AUTHORITIES THAT ALL REQUIRED PERMITS HAVE BEEN ACQUIRED.
- COORDINATE CONSTRUCTION IN THE RIGHT OF WAY WITH THE LOCAL AUTHORITIES.
- PROVIDE PROPER BARRICADES, SIGNS AND TRAFFIC CONTROL TO MAINTAIN THRU TRAFFIC ALONG ADJACENT STREETS IN ACCORDANCE WITH LOCAL MUNICIPAL REQUIREMENTS.
- SIDEWALK JOINTS TO BE AS INDICATED OR AS APPROVED BY CONSTRUCTION MANAGER.
- ALL SAWCUTS SHALL BE AT AN EXISTING JOINT IN THE CURB AND PAVEMENT.
- ALL GENERAL LANDSCAPE AREAS SHALL BE SEEDED/FERTILIZED/CRIMP HAY MULCHED IN ACCORDANCE WITH THE PROJECT SPECIFICATIONS.

IMPERVIOUS SURFACE RATIO



TOTAL LOT AREA = 12.08 ACRES	
IMPERVIOUS AREA	GREENSPACE AREA
6.32 ACRES (52.3% OF SITE)	5.76 ACRES (47.7% OF SITE)

KEYNOTES:

- 24" CONCRETE CURB & GUTTER
- HANDI-CAP RAMP
- PARKING LOT STRIPING
- DIRECTIONAL ARROW
- HANDICAP PARKING STALL
- HANDICAP PARKING SIGN
- ELECTRIC VEHICLE PARKING STALL (SEE ELECTRICAL SITE PLAN)
- MONUMENT SIGN (SEE ARCHITECTURAL PLANS)
- DAHU NO SCRATCH CIRCULAR BIKE RACK BY SPORTWORKS®
- 20' FLAG POLE
- 6'-0" WALL BY BUILDING CONTRACTOR (SEE ARCHITECTURAL PLANS)
- VISITOR PARKING SIGN
- 1'-6" TALL SEAT WALL (SEE ARCHITECTURAL PLANS)
- 8'x8" SEAT WALL PLANTER BOX (SEE ARCHITECTURAL PLANS)
- 4'x10' TREE GRATE
- BENCH (VERIFY PRODUCT/MATERIAL WITH ARCH.)
- REINFORCED CONCRETE APRON
- 6' TALL CHAIN LINK FENCE
- 6' TALL MAN GATE CHAIN LINK FENCE
- REINFORCED LOADING DOCK RAMP
- 2.0' WIDE CONCRETE STRIP
- 8.0' WIDE ASPHALT BICYCLE PATH
- 12"x12" CONCRETE PLAYGROUND CURB

PAVEMENT HATCH PATTERNS:

- | | | |
|--|--|----|
| 4" ASPHALTIC CONCRETE PAVEMENT
9" DENSE GRADED BASE | | 6 |
| 3.5" ASPHALTIC CONCRETE PAVEMENT
9" DENSE GRADED BASE | | 6 |
| 3.0" ASPHALTIC CONCRETE PAVEMENT
9" DENSE GRADED BASE | | 6 |
| 4" CONCRETE PAVEMENT (SIDEWALK)
6" BASE COURSE | | 7 |
| 6" REINFORCED CONCRETE PAVEMENT
10" BASE COURSE | | 7 |
| 3.5" POURED RUBBER PLAY SURFACE
6" COMPACTED STONE BASE | | 11 |

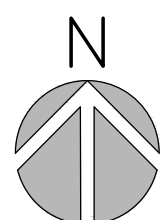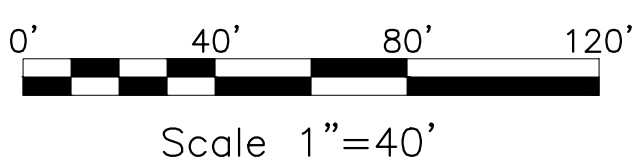


Office Locations:

Milwaukee
829 S. 1st Street
Milwaukee, Wisconsin 53204
T: 414.226.0200

Sheboygan
1227A North 8th Street
PO Box 955
Sheboygan, Wisconsin
53082
T: 920.459.4200
www.brayarch.com

Civil Engineering
Land Surveying
Landscape Architecture
5709 Winery Drive, Suite D
Stevens Point, WI 54482
715.341.9999 (p) 715.344.9922 (fx)

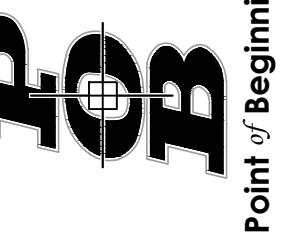

Project Title:
**NEW BUILDING:
OREGON ELEMENTARY SCHOOL
OREGON SCHOOL DISTRICT
FITCHBURG, WI 53711**

REVISIONS:		
DATE	DESCRIPTION	

**NOT FOR
CONSTRUCTION**


Project Number:
3322

Issued For:
**DESIGN
PROGRESS**

10/18/2018

Sheet Title:
LAYOUT PLAN


Sheet Number:
C2.0

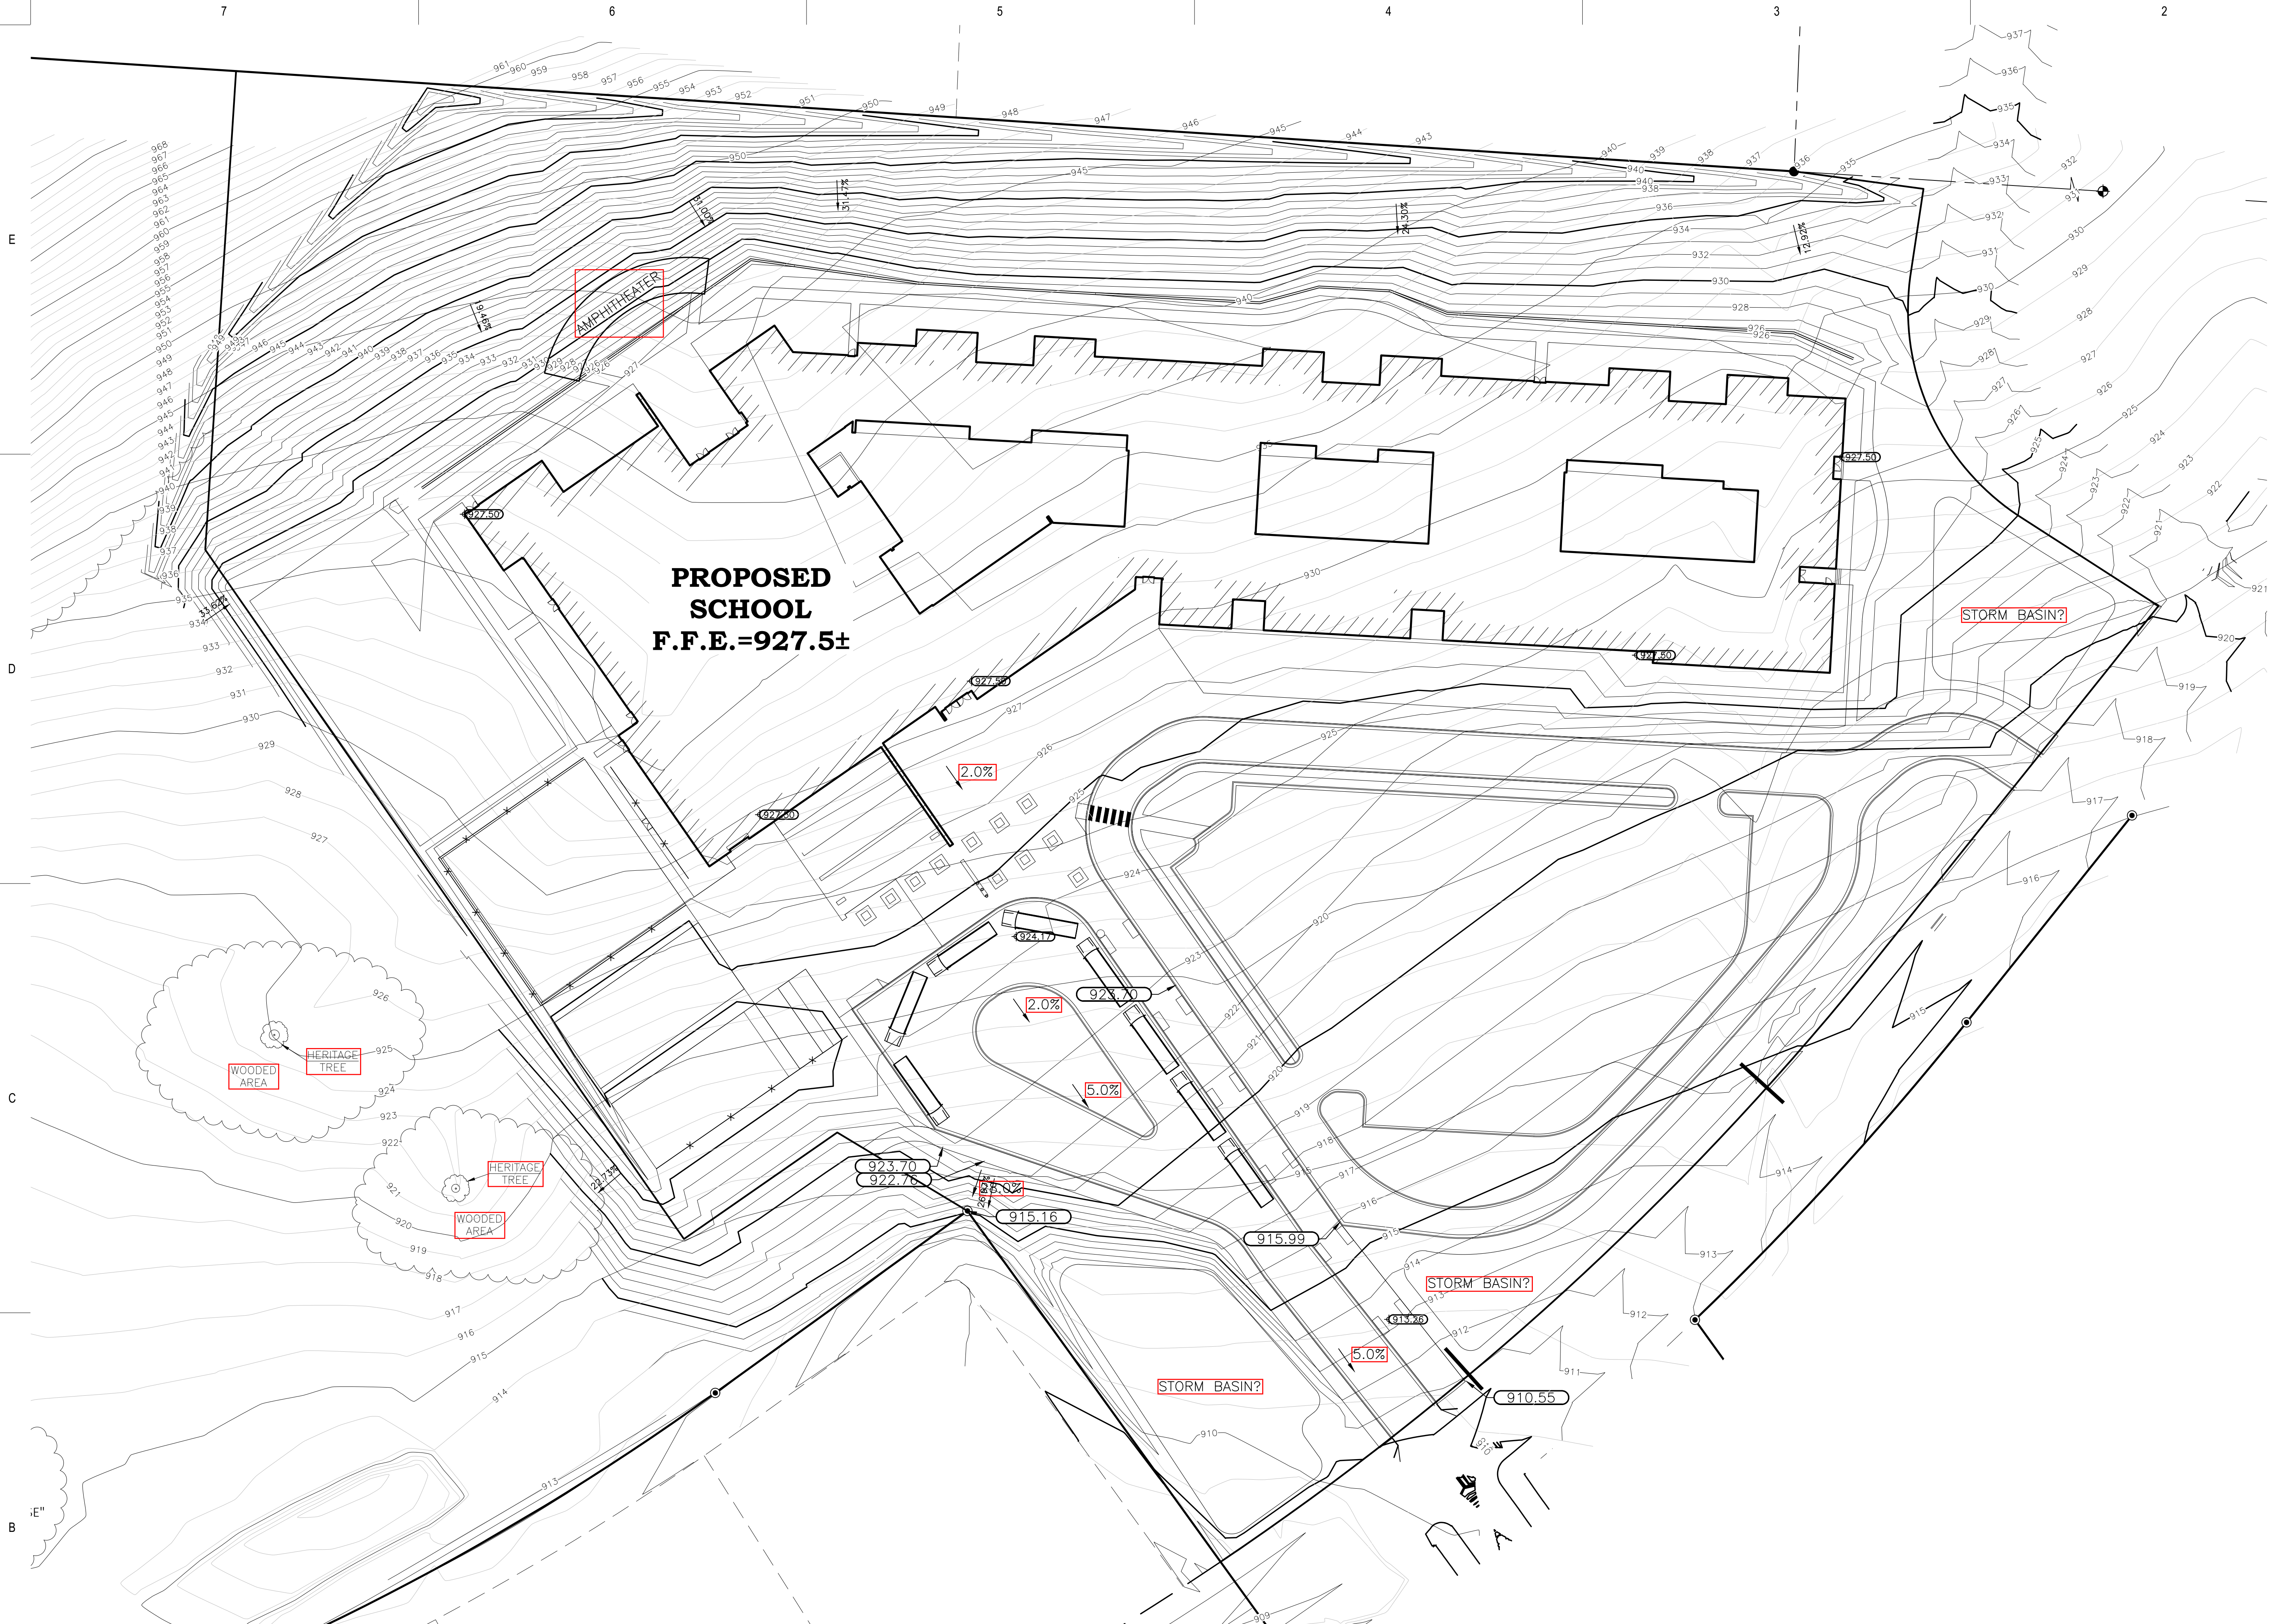

GENERAL NOTES:

1. CONTACT DIGGER'S HOTLINE 5 WORKING DAYS PRIOR TO THE START OF DEMOLITION/CONSTRUCTION.
2. THE PROPOSED SITE PLAN FINISH FLOOR ELEVATION OF 927.50 EQUALS THE PROPOSED BUILDING ARCHITECTURAL FINISH FLOOR ELEVATION OF 100.00'.
3. GRADE, LINE, AND LEVEL TO BE REVIEWED IN THE FIELD BY THE CONSTRUCTION MANAGER.
4. INSTALL AND MAINTAIN ALL REQUIRED EROSION CONTROL MEASURES IN ACCORDANCE WITH LOCAL AUTHORITIES AND THE DEPARTMENT OF NATURAL RESOURCES REGULATIONS.
5. 6" OF TOPSOIL SHALL BE PROVIDED IN ALL GENERAL LAWN AREAS AND 12" SHALL BE PROVIDED IN ALL PLANTING BED AREAS.
6. SEE SHEET C4.0 FOR ALL REQUIRED EROSION CONTROL ELEMENTS.
7. ANY EXISTING UTILITIES NOT SHOWN ON THIS DOCUMENT WHICH NEED TO BE REMOVED, RELOCATED OR ADJUSTED SHALL BE THE RESPONSIBILITY OF THE SITE GRADING CONTRACTOR AND INCLUDED IN THE BASE BID CONTRACT.
8. COORDINATE ALL EARTHWORK ACTIVITIES WITH THE RESPECTIVE TRADES RESPONSIBLE FOR THE INSTALLATION OF GAS, CABLE, TELEPHONE AND ELECTRICAL (INCLUDING MAIN SERVICE, SITE LIGHTING, CONDUITS AND SIGNAGE).
9. PROVIDE RIP RAP AT PROPOSED CULVERT ENDWALL STRUCTURES TO PREVENT WASHOUT AND EROSION.
10. RIP RAP SHALL HAVE W8DOT TYPE HR FILTER FABRIC PLACED BENEATH.
11. EXCESS TOPSOIL SHALL BE REMOVED FROM SITE, UNLESS OTHERWISE DIRECTED BY THE OWNER. COORDINATE WITH OWNER FOR LOCATION OF STOCKPILE IF THE OWNER CHOOSES TO SALVAGE EXCESS TOPSOIL FOR FUTURE USE. SILT FENCE SHALL BE PLACED AROUND STOCKPILE.
12. THE ENGINEERED SOIL SHALL NOT BE PLACED IN THE BIORETENTION AREAS UNTIL THE SURROUNDING DRAINAGE AREA HAS BEEN FULLY STABILIZED. ALL CONSTRUCTION SITE SEDIMENT SHALL BE REMOVED FROM THE SUBGRADE OF THE BIORETENTION AREA PRIOR TO PLACEMENT OF THE ENGINEERED SOIL.
13. TESTING AND INSPECTION SHALL BE DONE IN ACCORDANCE WITH SPS 382.21.
14. THE LOCAL MUNICIPALITY SHALL BE CONTACTED PRIOR TO ANY EXCAVATION IN THE PUBLIC RIGHT-OF-WAY. THE CONTRACTOR SHALL HAVE HIS TRAFFIC CONTROL PLAN APPROVED PRIOR TO WORK COMMENCING. THE LOCAL MUNICIPALITY SHALL OPERATE ALL EXISTING WATER VALVES IF NEEDED.
15. GRADES AT BUILDING EDGE SHALL BE 6" BELOW FINISHED FLOOR ELEVATION EXCEPT AT DOOR WAY ENTRANCES OR UNLESS OTHERWISE NOTED.

BENCH MARK
ELEVATIONS ARE REFERENCED TO NAVD 88 DATUM.
BENCHMARK #1
B&B SPIKE IN POWER POLE, LOCATED ON THE EAST SIDE OF C.T.H. "MM" AND BEING APPROXIMATELY 300 FEET SOUTH OF THE NORTHWEST CORNER OF THE SUBJECT PROPERTY.
ELEVATION = 940.78
BENCHMARK #2
B&B SPIKE IN POWER POLE, LOCATED ON THE WEST SIDE OF C.T.H. "MM" AND BEING APPROXIMATELY 500 SOUTH OF BENCHMARK #1.
ELEVATION = 913.64

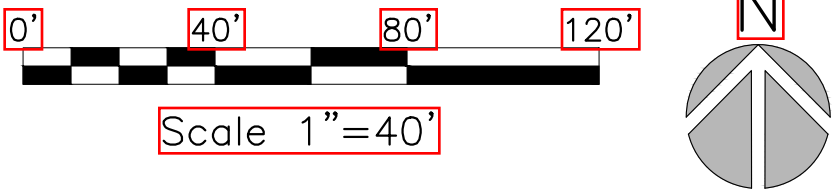

Office Locations:
Milwaukee
829 S. 1st Street
Milwaukee, Wisconsin 53204
T: 414.226.0200
Sheboygan
1227A North 8th Street
PO Box 955
Sheboygan, Wisconsin
53082
T: 920.459.4200
www.brayarch.com

Civil Engineering
Land Surveying
Landscape Architecture
5709 Windy Drive, Suite D
Stevens Point, WI 54482
715.341.5777 (p) 715.344.4722 (fx)
Point of Beginning

Project Title:
**NEW BUILDING:
OREGON ELEMENTARY SCHOOL
OREGON SCHOOL DISTRICT
FITCHBURG, WI 53711**

REVISIONS:		
DATE	DESCRIPTION	


**NOT FOR
CONSTRUCTION**

Project Number:
3322

Issued For:
**DESIGN
PROGRESS**

Sheet Title:
GRADING PLAN

Sheet Number:
C3.0

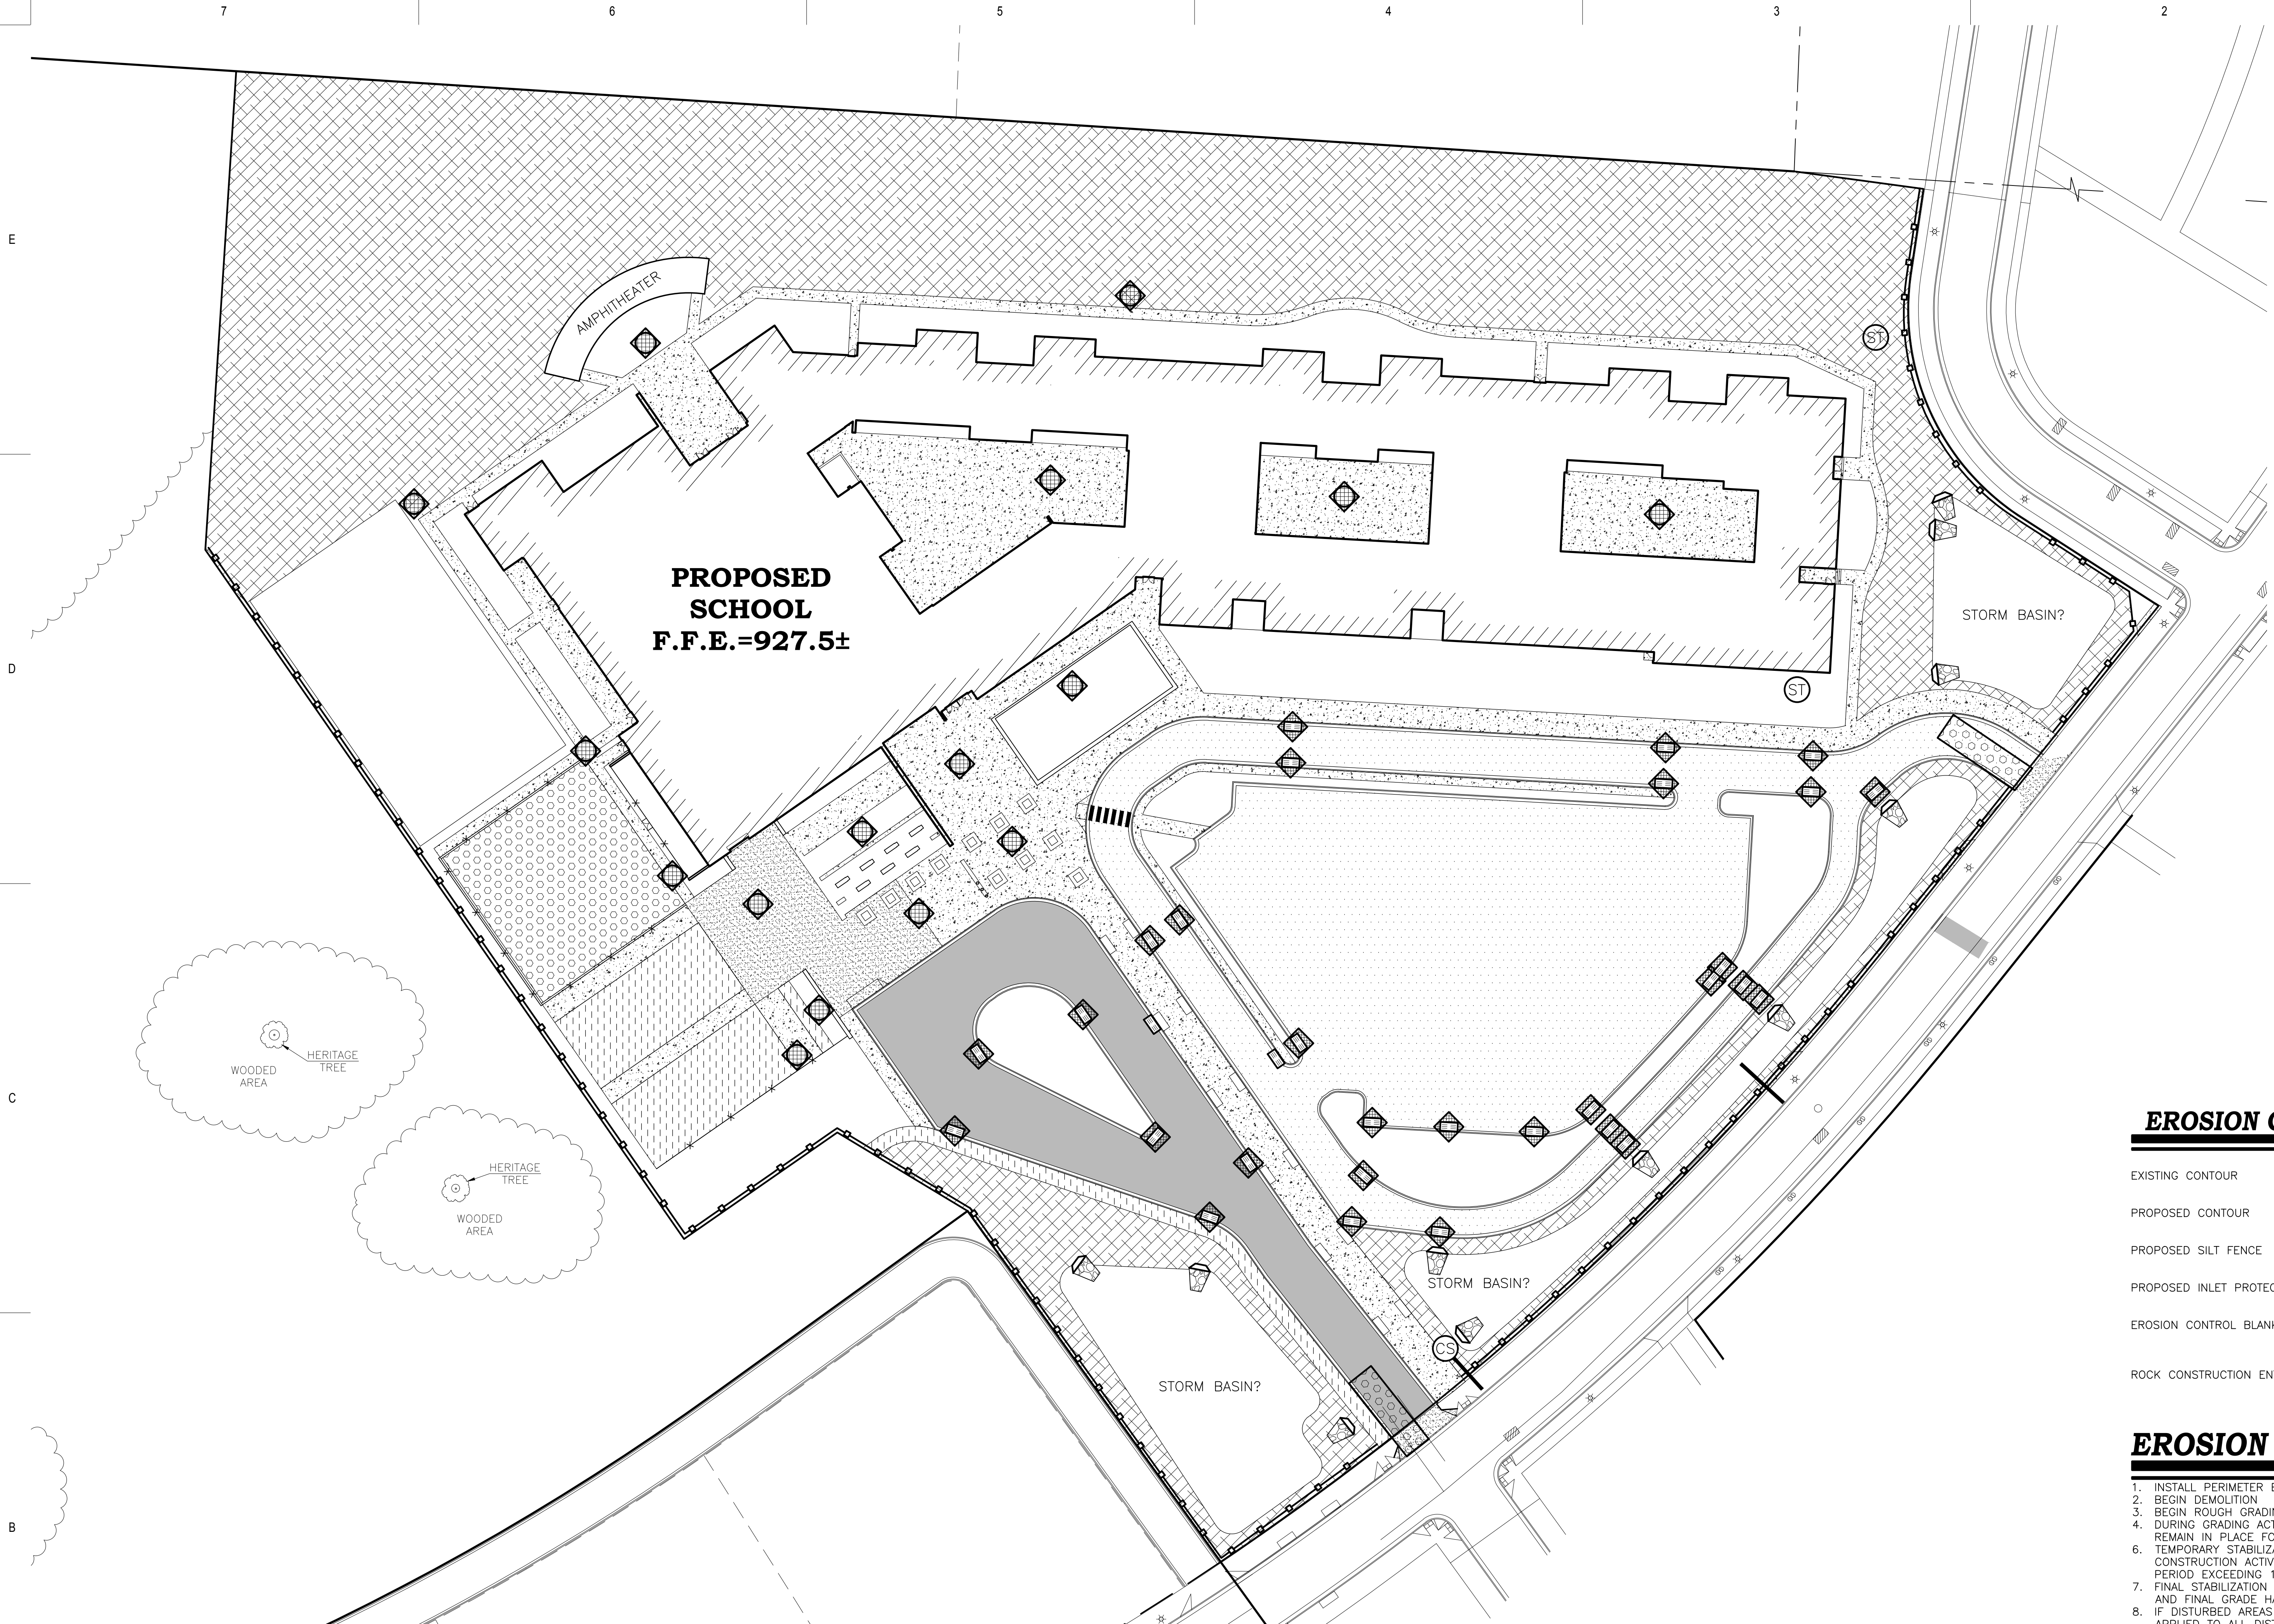

GENERAL NOTES:



1. CONTACT DIGGER'S HOTLINE 5 WORKING DAYS PRIOR TO THE START OF DEMOLITION/CONSTRUCTION.
2. NOTIFY THE LOCAL MUNICIPALITY AT LEAST 2 WORKING DAYS PRIOR TO THE START OF SOIL DISTURBING ACTIVITIES.
3. INSTALL ALL TEMPORARY EROSION CONTROL ELEMENTS PRIOR TO THE START OF DEMOLITION/CONSTRUCTION.
4. ALL ACTIVITIES SHALL BE CONDUCTED IN A LOGICAL SEQUENCE AS TO MINIMIZE THE AMOUNT OF BARE SOIL EXPOSED AT ANY ONE TIME. MAINTAIN EXISTING VEGETATION AS LONG AS POSSIBLE.
5. CRUSHED ROCK DRIVES FOR SEDIMENT TRACKING UTILIZING 3" CRUSHED ROCK SHALL BE MAINTAINED AT ALL CONSTRUCTION ENTRANCES TO THE SITE. THE ROCK DRIVE SHALL BE A MINIMUM OF 12" THICK AND BE A MINIMUM OF 50 FEET IN LENGTH BY THE WIDTH OF THE DRIVEWAY.
6. OFF SITE SEDIMENT DEPOSITS OCCURRING AS A RESULT OF A STORM EVENT SHALL BE CLEANED UP BY THE END OF THE NEXT WORK DAY. ALL OFF SITE SEDIMENT DEPOSITS OCCURRING AS A RESULT OF CONSTRUCTION ACTIVITIES, INCLUDING SOIL TRACKED BY CONSTRUCTION TRAFFIC, SHALL AT A MINIMUM BE CLEANED BY THE END OF EACH WORK DAY. EXCESSIVE AMOUNTS OF SEDIMENT OR OTHER DEBRIS TRACKED ONTO ADJACENT STREETS SHALL BE CLEANED IMMEDIATELY. FINE SEDIMENT ACCUMULATIONS SHALL BE CLEANED FROM ADJACENT STREETS BY THE USE OF MECHANICAL OR MANUAL SWEEPING OPERATIONS ONCE A WEEK AT A MINIMUM AND BEFORE IMMINENT RAIN EVENTS.
7. DISTURBED GROUND OUTSIDE OF THE EVERYDAY CONSTRUCTION AREAS, INCLUDING SOIL STOCKPILES, THAT IS LEFT INACTIVE FOR MORE THAN 7 DAYS SHALL BE TEMPORARILY STABILIZED BY SEEDING/MULCHING OR OTHER APPROVED METHODS.
8. WASTE MATERIAL THAT IS GENERATED ON THE CONSTRUCTION SITE SHALL BE PROPERLY DISPOSED OF AND NOT ALLOWED TO RUN INTO RECEIVING WATERS.
9. EROSION CONTROL DEVICES DESTROYED AS A RESULT OF CONSTRUCTION ACTIVITIES SHALL BE REPAIRED BY THE END OF EACH WORK DAY.
10. INSPECT ALL EROSION CONTROL MEASURES AT LEAST ONCE A WEEK AND AFTER ANY RAINFALL OF 0.5" OR MORE. MAKE NEEDED REPAIRS AND DOCUMENT ALL ACTIVITIES AS PER THE REQUIREMENTS OF THE NOTICE OF INTENT SUBMITTED BY THE PROJECT CIVIL ENGINEER.
11. ALL TEMPORARY EROSION CONTROL ELEMENTS SHALL REMAIN IN PLACE UNTIL A SUFFICIENT GROWTH OF VEGETATION IS ESTABLISHED AND THEN BE REMOVED AS PART OF THE BASE BID.
12. IF SEDIMENT LADEN WATER NEEDS TO BE REMOVED FROM THE SITE, FILTER BAGS OR SCREENING SHALL BE USED IN ACCORDANCE WITH WDNR TECHNICAL STANDARD 1061 TO PREVENT SEDIMENT DISCHARGE TO THE MAXIMUM EXTENT PRACTICABLE.
12. PROVIDE RIP RAP AT PROPOSED CULVERT ENDWALL STRUCTURES TO PREVENT WASHOUT AND EROSION.
13. RIP RAP SHALL HAVE W6DOT TYPE HR FILTER FABRIC PLACED BENEATH.
14. IF BARE SOIL IS EXPOSED DURING THE WINTER MONTHS, STABILIZATION BY MULCHING OR ANIONIC POLYACRYLAMIDE SHALL OCCUR PRIOR TO SNOW OR FROZEN GROUND.
15. SILT FENCE SHALL BE INSTALLED AROUND THE TOPSOIL STOCKPILE.
16. SILT FENCE SHALL BE INSTALLED AROUND THE BIORETENTION AREA IMMEDIATELY FOLLOWING INSTALLATION OF THE ENGINEERED SOIL TO PROTECT IT FROM SILT CONTAMINATION.
17. THE ENGINEERED SOIL SHALL NOT BE PLACED IN THE BIORETENTION AREAS UNTIL THE SURROUNDING DRAINAGE AREA HAS BEEN FULLY STABILIZED. ALL CONSTRUCTION SITE SEDIMENT SHALL BE REMOVED FROM THE SUBGRADE OF THE BIORETENTION AREA PRIOR TO PLACEMENT OF THE ENGINEERED SOIL.
18. THE CONTRACTOR SHALL PERFORM INSPECTIONS AND MONITORING OF EROSION CONTROL PRACTICES IN ACCORDANCE WITH THE WI DNR "CONSTRUCTION SITE INSPECTION REPORT" FORM 3400-187. THIS FORM CAN BE FOUND IN THE CONSTRUCTION SPECIFICATIONS.

EROSION CONTROL LEGEND:

EXISTING CONTOUR	888	X XX
PROPOSED CONTOUR	888	Y XY
PROPOSED SILT FENCE		Z XZ
PROPOSED INLET PROTECTION		Y YZ
EROSION CONTROL BLANKET		Y YZ
ROCK CONSTRUCTION ENTRANCE		Y XY


EROSION CONTROL SEQUENCING

1. INSTALL PERIMETER EROSION CONTROL.
2. BEGIN DEMOLITION
3. BEGIN ROUGH GRADING AND UTILITY INSTALLATION
4. DURING GRADING ACTIVITIES EXISTING GRASS AND VEGETATION, TO BE REMOVED, SHALL REMAIN IN PLACE FOR AS LONG AS POSSIBLE, TO AVOID SEDIMENT TRANSPORT.
6. TEMPORARY STABILIZATION ACTIVITY SHALL COMMENCE WHEN LAND DISTURBING CONSTRUCTION ACTIVITIES HAVE TEMPORARILY CEASED AND WILL NOT RESUME FOR A PERIOD EXCEEDING 14 CALENDAR DAYS.
7. FINAL STABILIZATION ACTIVITY SHALL COMMENCE WHEN LAND DISTURBING ACTIVITIES CEASE AND FINAL GRADE HAS BEEN REACHED ON ANY PORTION OF THE SITE.
8. IF DISTURBED AREAS MUST BE LEFT OVER WINTER, AN ANIONIC POLYACRYLAMIDE SHALL BE APPLIED TO ALL DISTURBED AREAS PRIOR TO GROUND FREEZE. SEE SPECIFICATIONS FOR DETAILS.

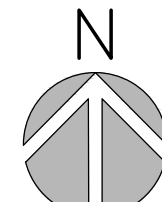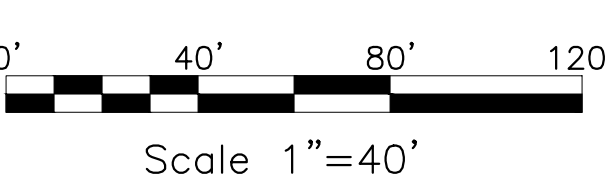

Office Locations:
Milwaukee
829 S. 1st Street
Milwaukee, Wisconsin 53204
T: 414.226.0200
Sheboygan
1227A North 8th Street
PO Box 955
Sheboygan, Wisconsin
53082
T: 920.459.4200
www.brayarch.com

Civil Engineering
Land Surveying
Landscape Architecture
5709 Wincy Drive, Suite D
Sevens Point, WI 54482
715.341.9797 (cell) 715.344.9721 (fax)

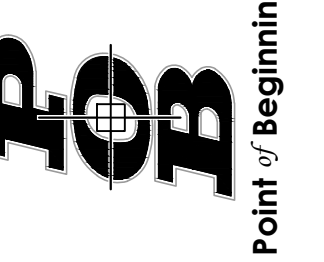

Project Title:
NEW BUILDING:
OREGON ELEMENTARY SCHOOL
OREGON SCHOOL DISTRICT
FITCHBURG, WI 53711

REVISIONS:

#	DATE	DESCRIPTION
---	------	-------------


NOT FOR
CONSTRUCTION

Project Number:
3322

Issued For:
DESIGN
PROGRESS
10/18/2018

Sheet Title:
EROSION
CONTROL PLAN

Sheet Number:
C4.0

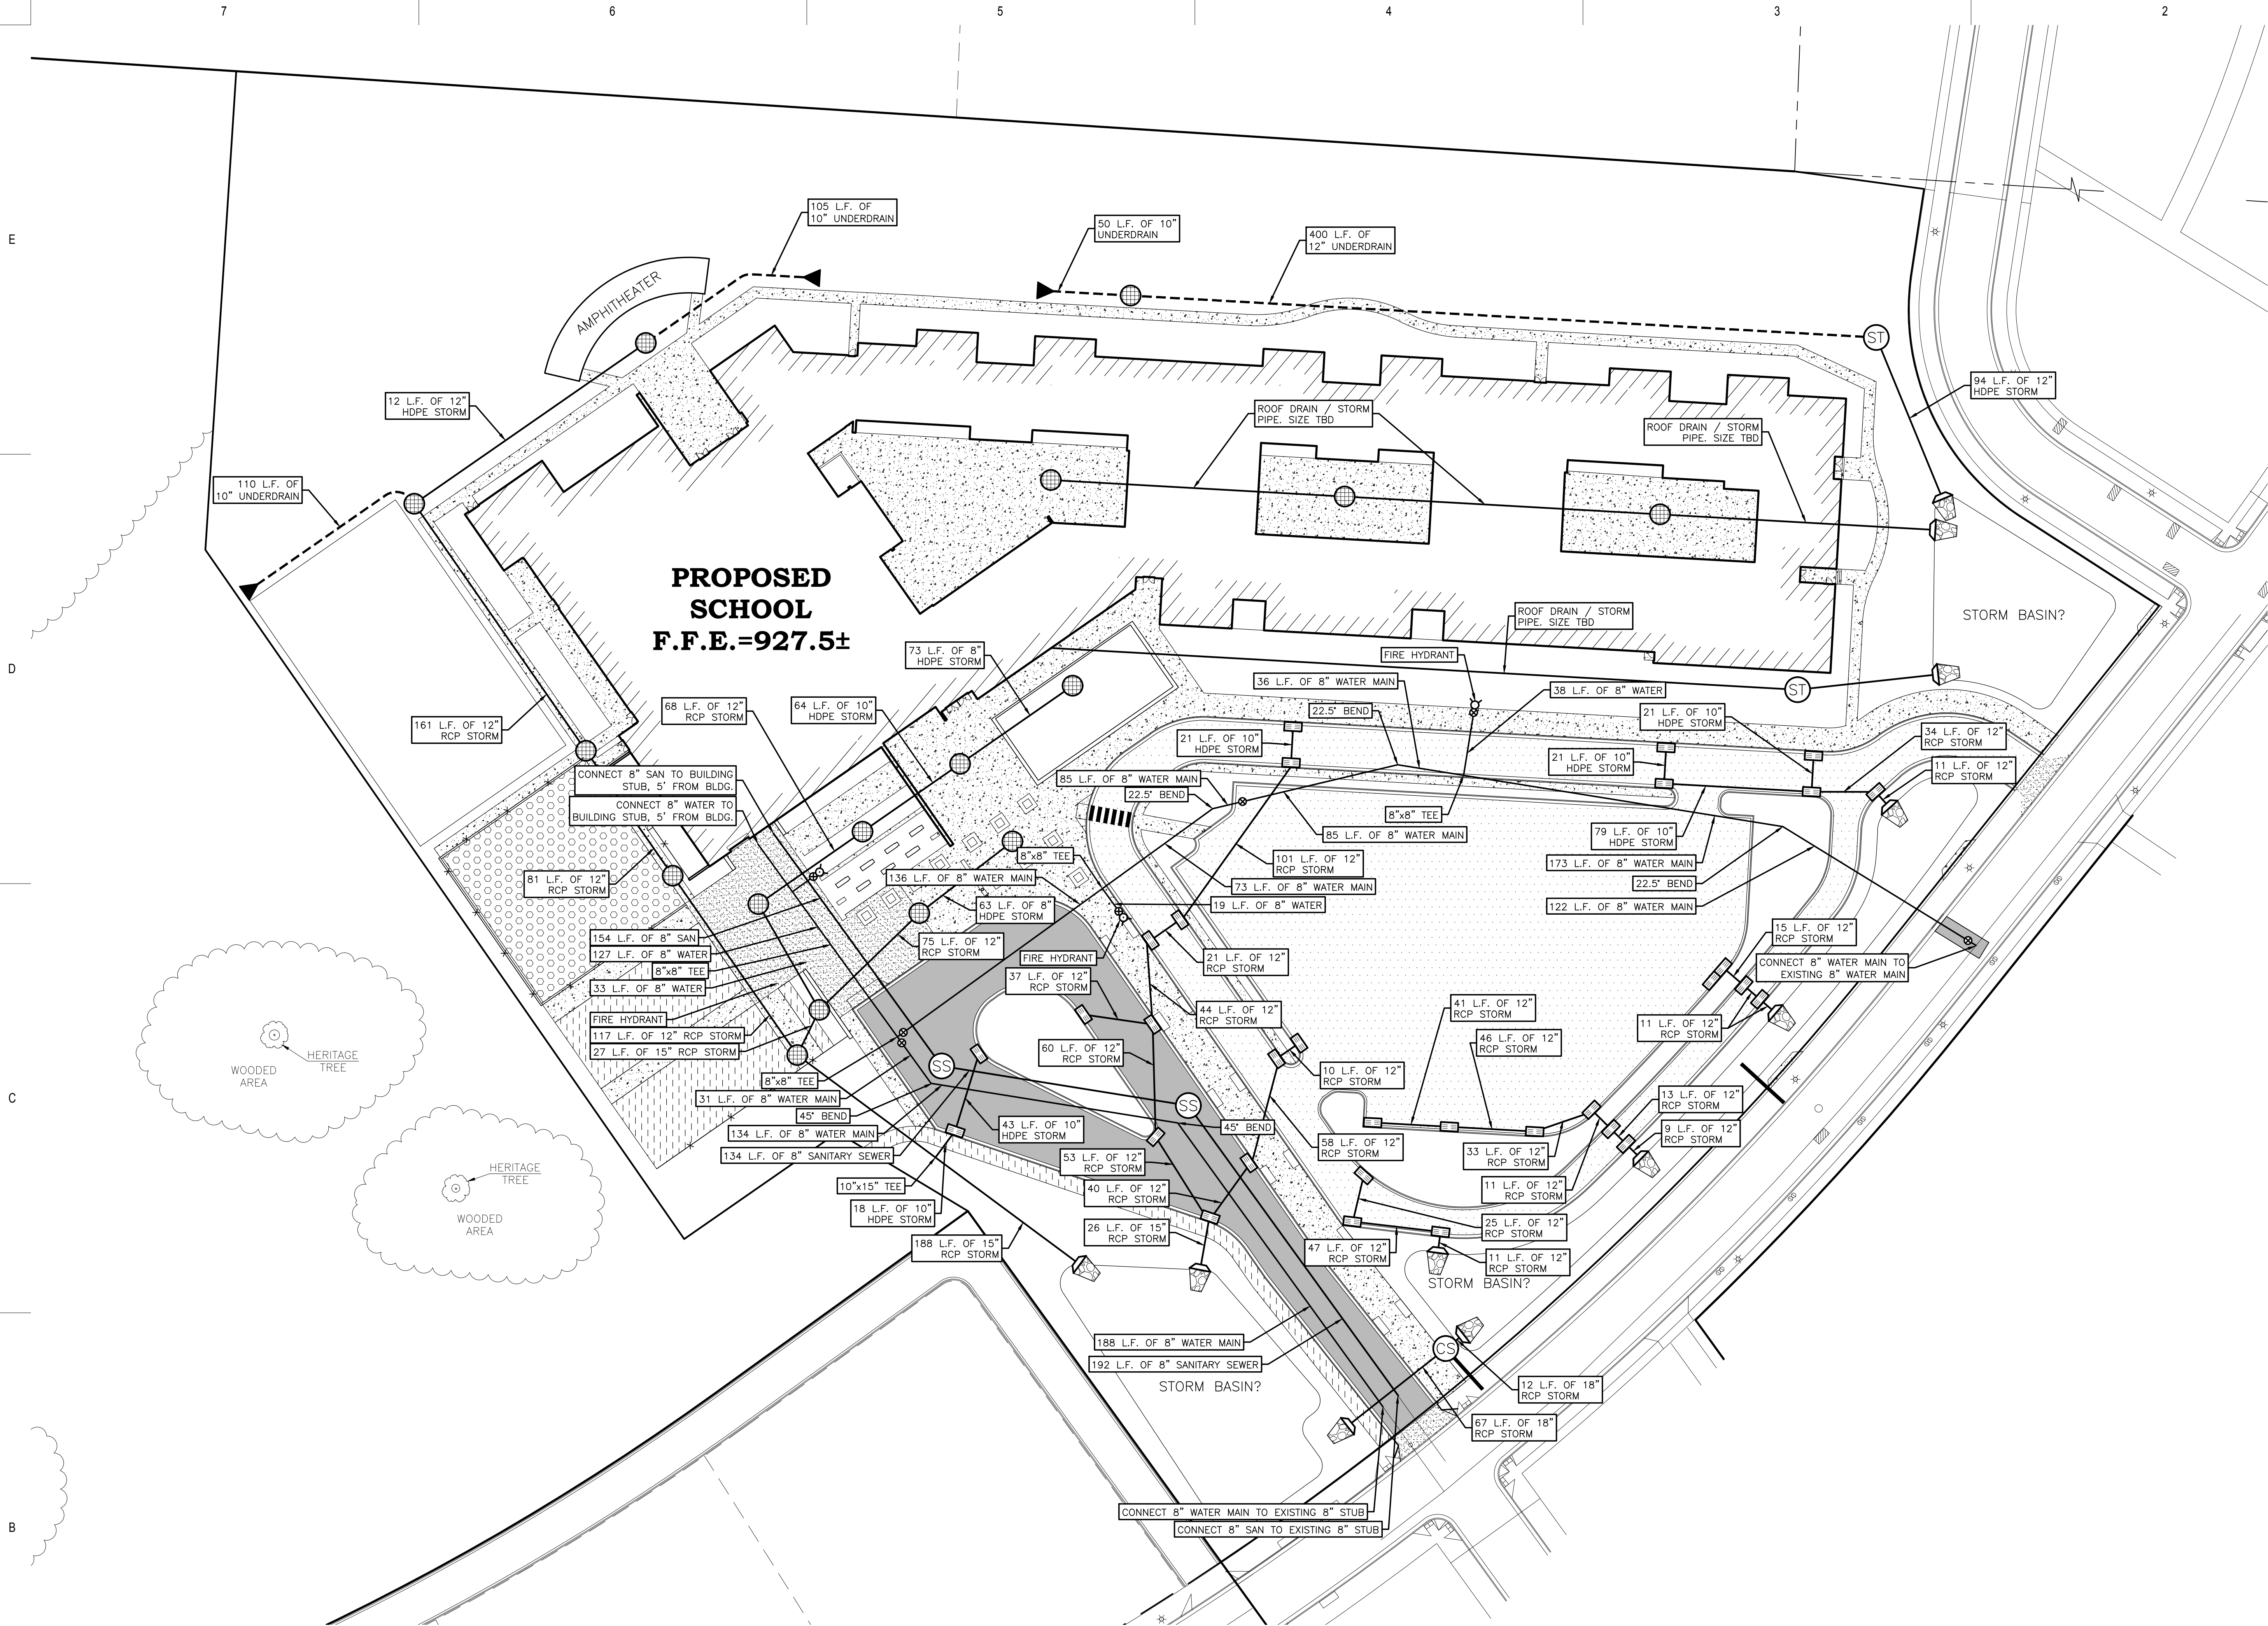



GENERAL NOTES:

1. CONTACT DIGGER'S HOTLINE 5 WORKING DAYS PRIOR TO THE START OF CONSTRUCTION.
2. GRADE, LINE, AND LEVEL SHALL BE REVIEWED IN THE FIELD BY THE CONSTRUCTION MANAGER.
3. ANY EXISTING UTILITIES NOT SHOWN ON THIS DOCUMENT WHICH NEED TO BE REMOVED, RELOCATED OR ADJUSTED SHALL BE THE RESPONSIBILITY OF THE SITE GRADING CONTRACTOR.
4. VERIFY EXACT SANITARY SEWER/WATER LATERAL CONNECTION LOCATIONS AND SIZES WITH THE BUILDING MECHANICAL/PLUMBING PLANS.
5. COORDINATE ALL UTILITY WORK WITH THE RESPECTIVE TRADES RESPONSIBLE FOR THE INSTALLATION OF GAS, CABLE, TELEPHONE AND ELECTRICAL (INCLUDING MAIN SERVICE, SITE LIGHTING, CONDUITS AND SIGNAGE).
6. COORDINATE ALL WORK WITH THE PUBLIC RIGHT OF WAY WITH THE LOCAL MUNICIPALITY.
7. TESTING AND INSPECTION SHALL BE DONE IN ACCORDANCE WITH SPS 382.21.
8. THE PROPOSED WATER MAIN/LATERAL SHALL HAVE A MINIMUM COVER OF 7'-6" FROM TOP OF PIPE TO PROPOSED FINISHED GRADES. SEE SHEET FOR PROPOSED GRADES.
9. THE MUNICIPALITY SHALL BE CONTACTED PRIOR TO ANY EXCAVATION IN THE PUBLIC RIGHT-OF-WAY AND PRIOR TO CONNECTING SANITARY SEWER AND WATER LATERALS TO THE PUBLIC MAINS. THE CONTRACTOR SHALL HAVE A TRAFFIC CONTROL PLAN APPROVED PRIOR TO WORK COMMENCING. THE MUNICIPALITY SHALL OPERATE EXISTING WATER VALVES, IF NEEDED.
10. FIELD VERIFY INVERT ELEVATION OF THE SANITARY SEWER AND WATER PUBLIC MAIN AT THE LOCATION OF THE SERVICE LATERAL CONNECTIONS, PRIOR TO CONNECTING THE LATERALS TO THE PUBLIC MAIN.
11. PROVIDE RIP RAP AT PROPOSED CULVERT ENDWALL STRUCTURES TO PREVENT WASHOUT AND EROSION.
12. RIP RAP SHALL HAVE WisDOT TYPE HR FILTER FABRIC PLACED BENEATH.


UTILITY LEGEND:

PROPOSED STORM SEWER	X"ST
PROPOSED SANITARY SEWER	X"SS
PROPOSED WATER MAIN	X"W
PROPOSED STORM UNDERDRAIN	X"UD
PROPOSED ENDWALL STRUCTURE WITH RIP RAP	18 C6.0
PROPOSED ENDWALL STRUCTURE WITHOUT RIP RAP	18 C6.0
PROPOSED STORM SEWER MANHOLE	18 C6.0
PROPOSED SANITARY SEWER MANHOLE	20 C6.0
PROPOSED STORM SEWER CONTROL STRUCTURE	19 C6.0
PROPOSED STORM SEWER CLEANOUT	1.2 C6.1
PROPOSED FIRE HYDRANT ASSEMBLY	3 C6.1
PROPOSED 8" WATER MAIN VALVE	16 C6.0
STORM CATCH BASIN INLET	17 C6.0
STORM CURB INLET	

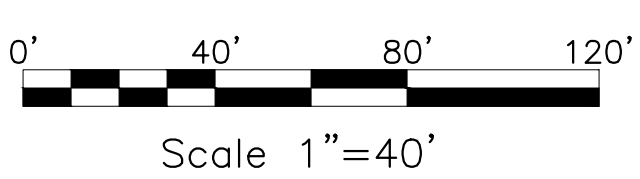


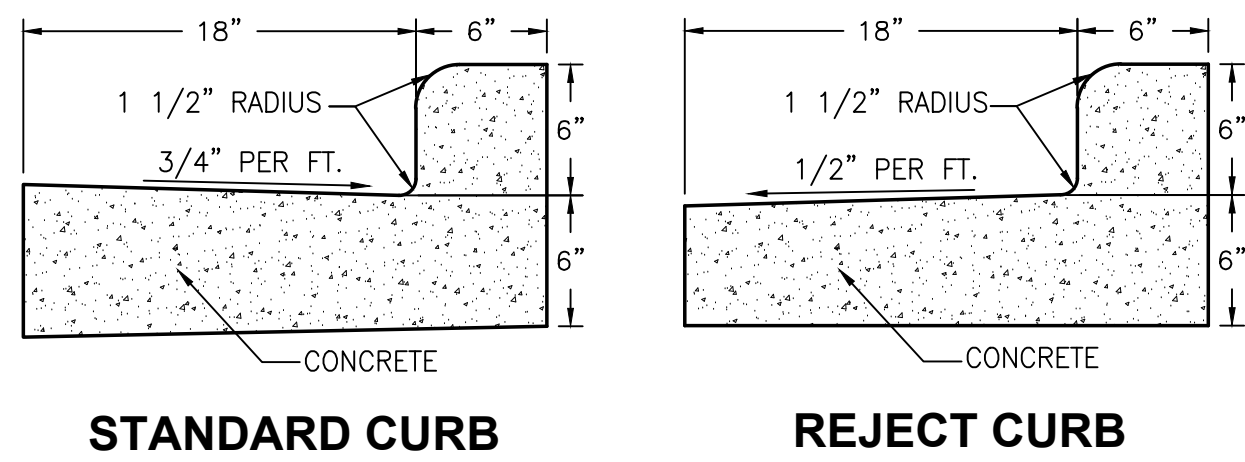


24" CURB AND GUTTER

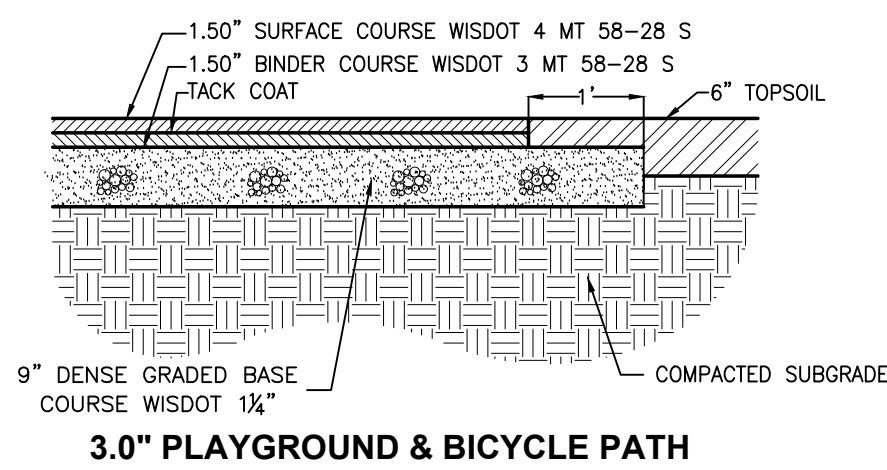

3.0" PLAYGROUND & BICYCLE PATH

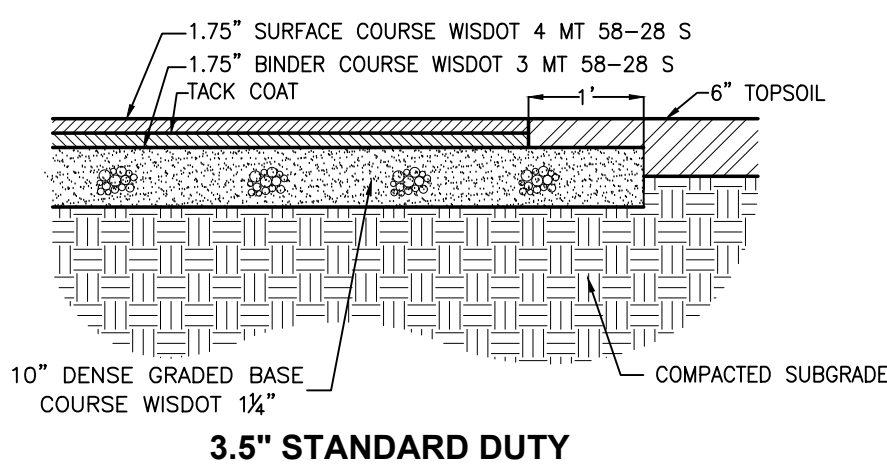


3.5" STANDARD DUTY

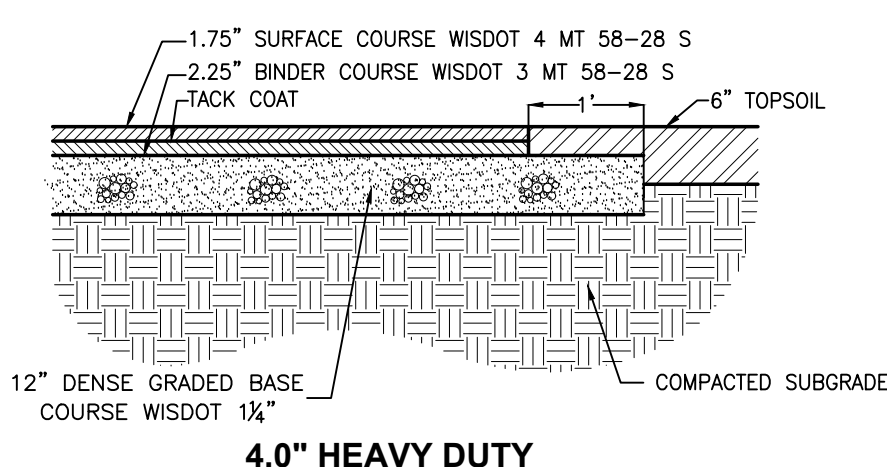


4.0" HEAVY DUTY


ASPHALT PAVEMENT

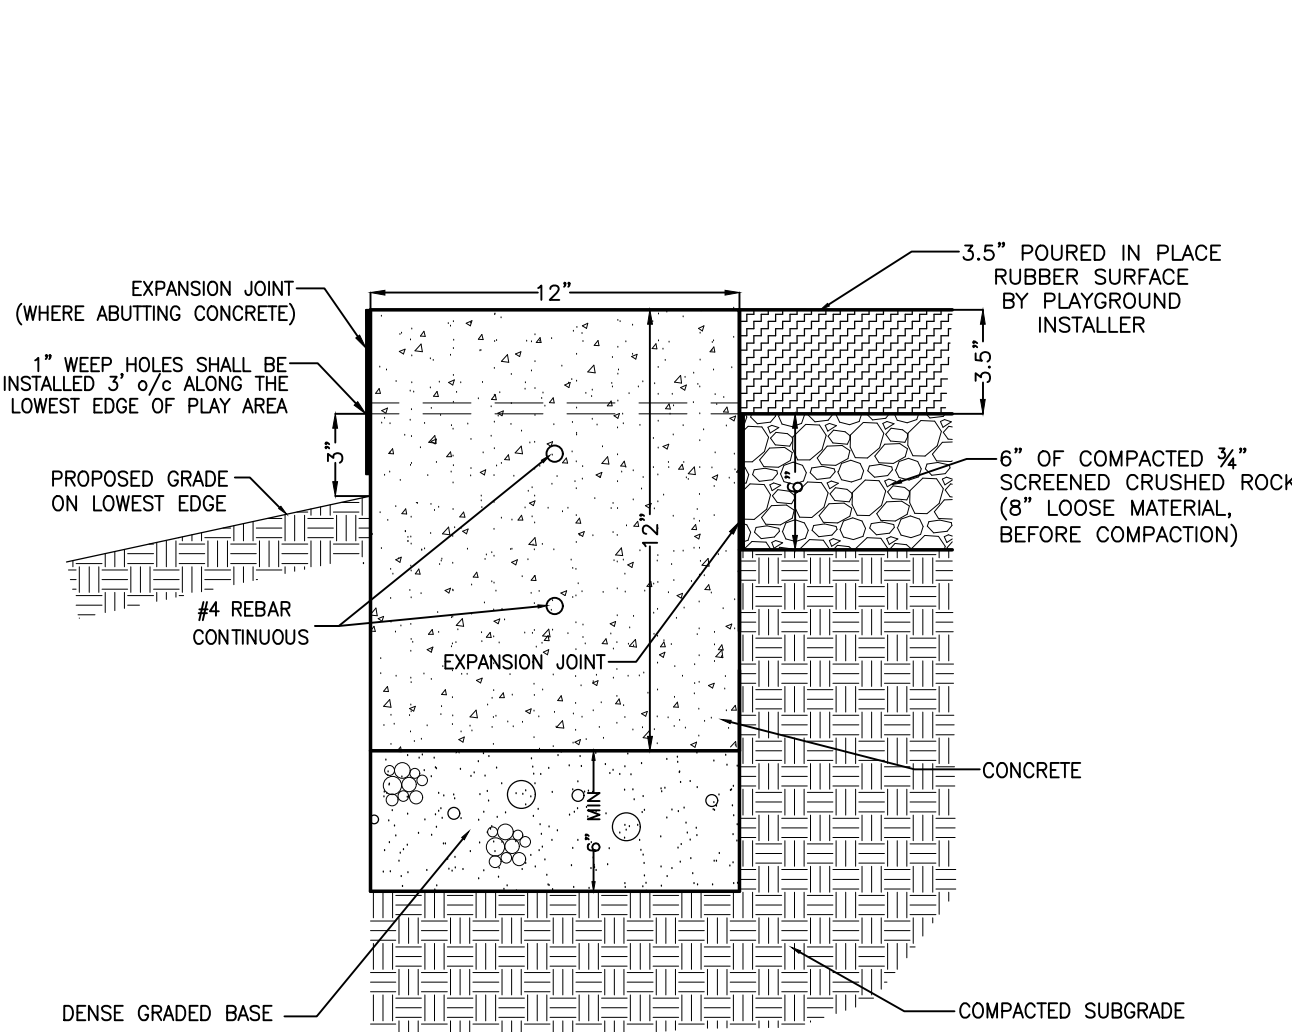


12"x12" CONCRETE PLAYGROUND CURB

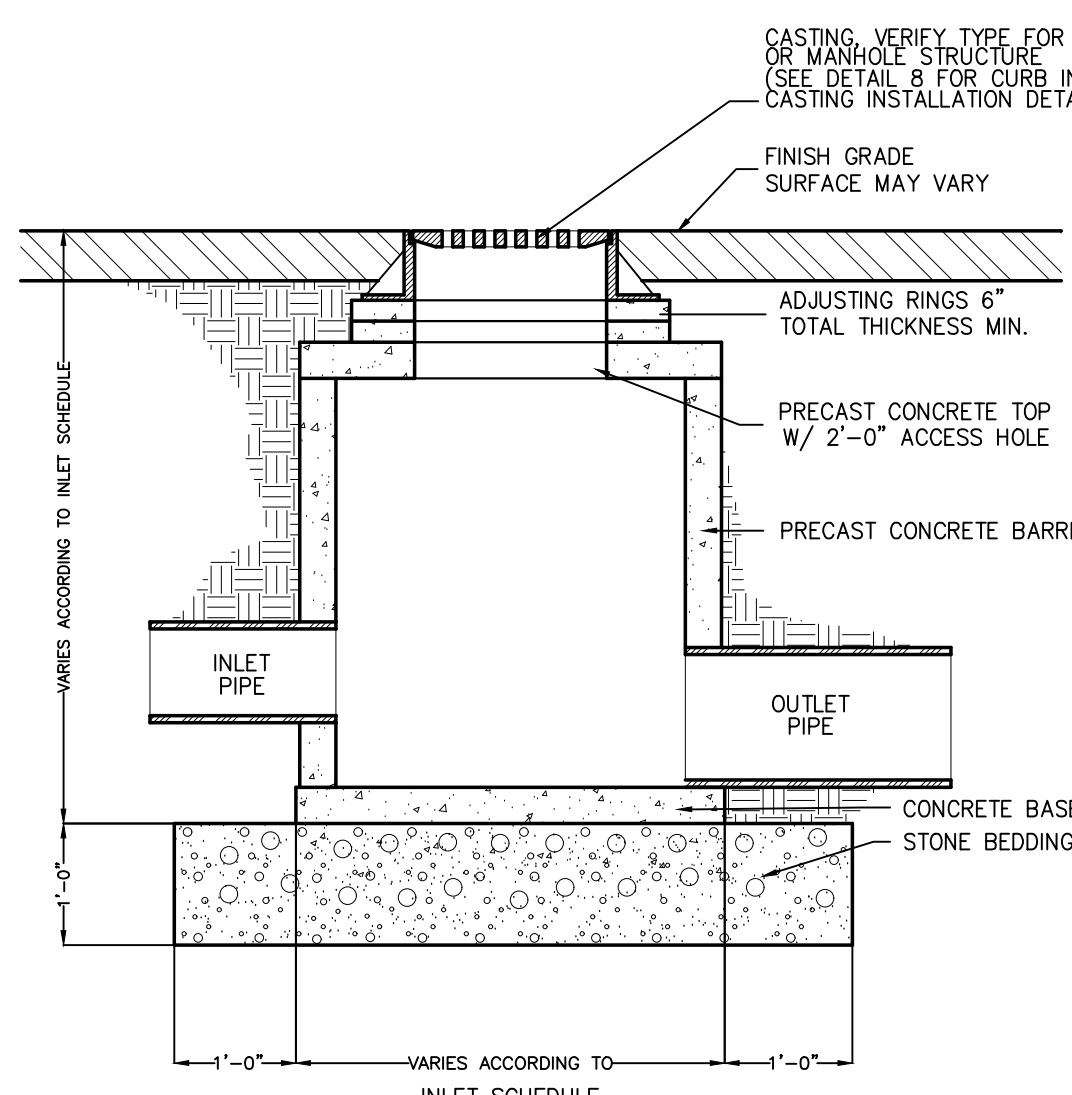

STORM MANHOLE

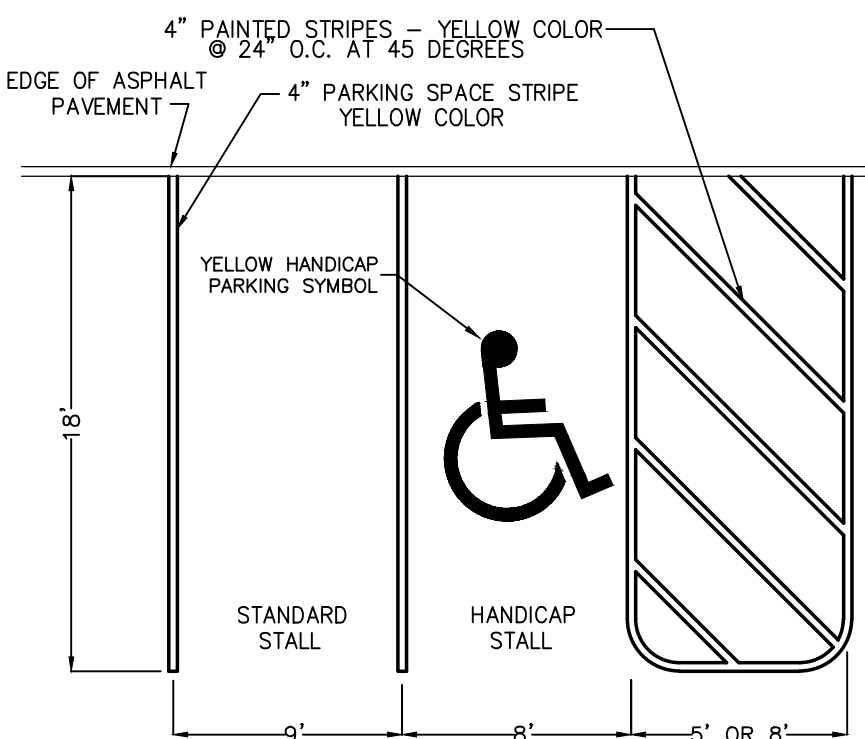


PARKING LOT STRIPING

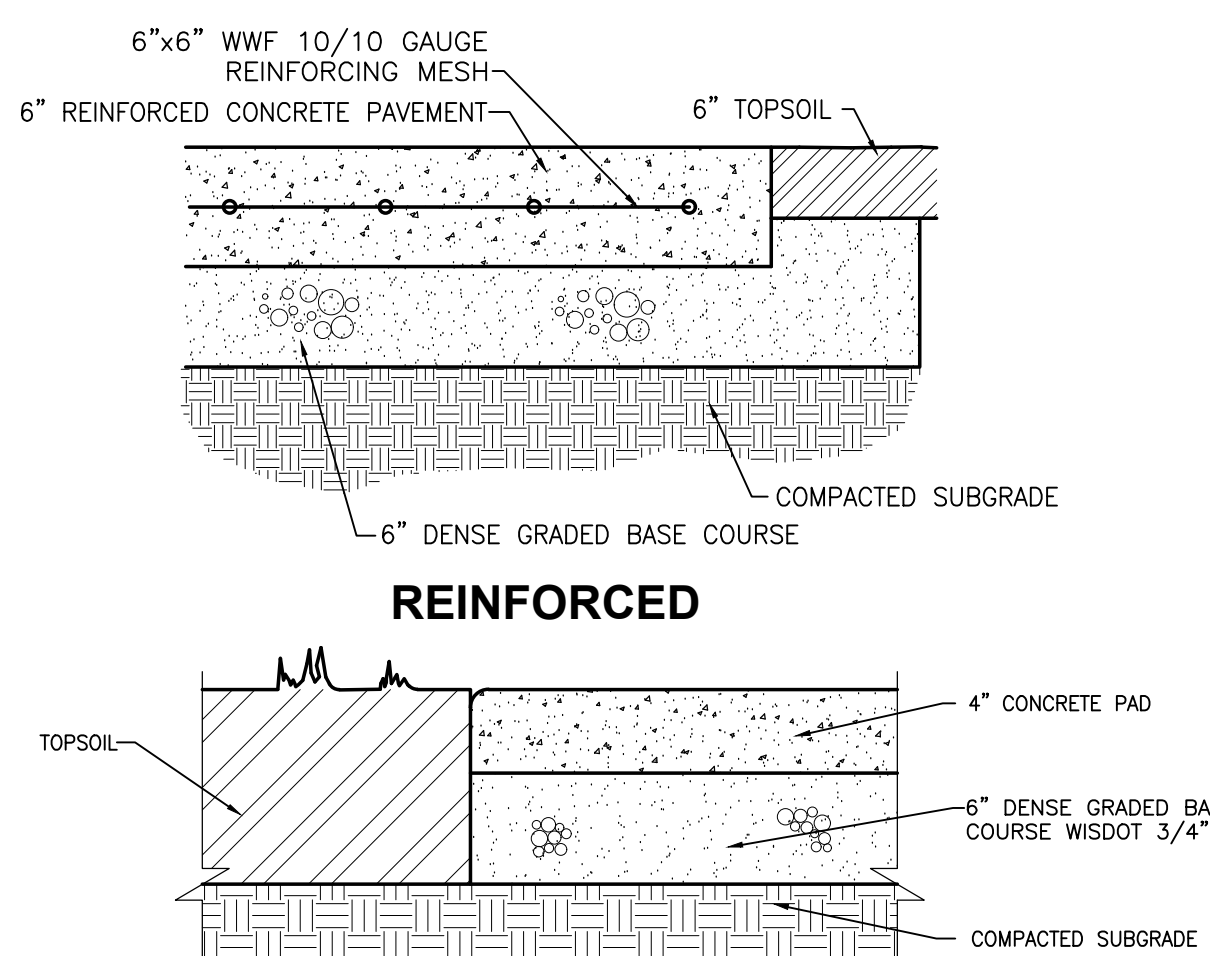


REINFORCED


CONCRETE PAVEMENT

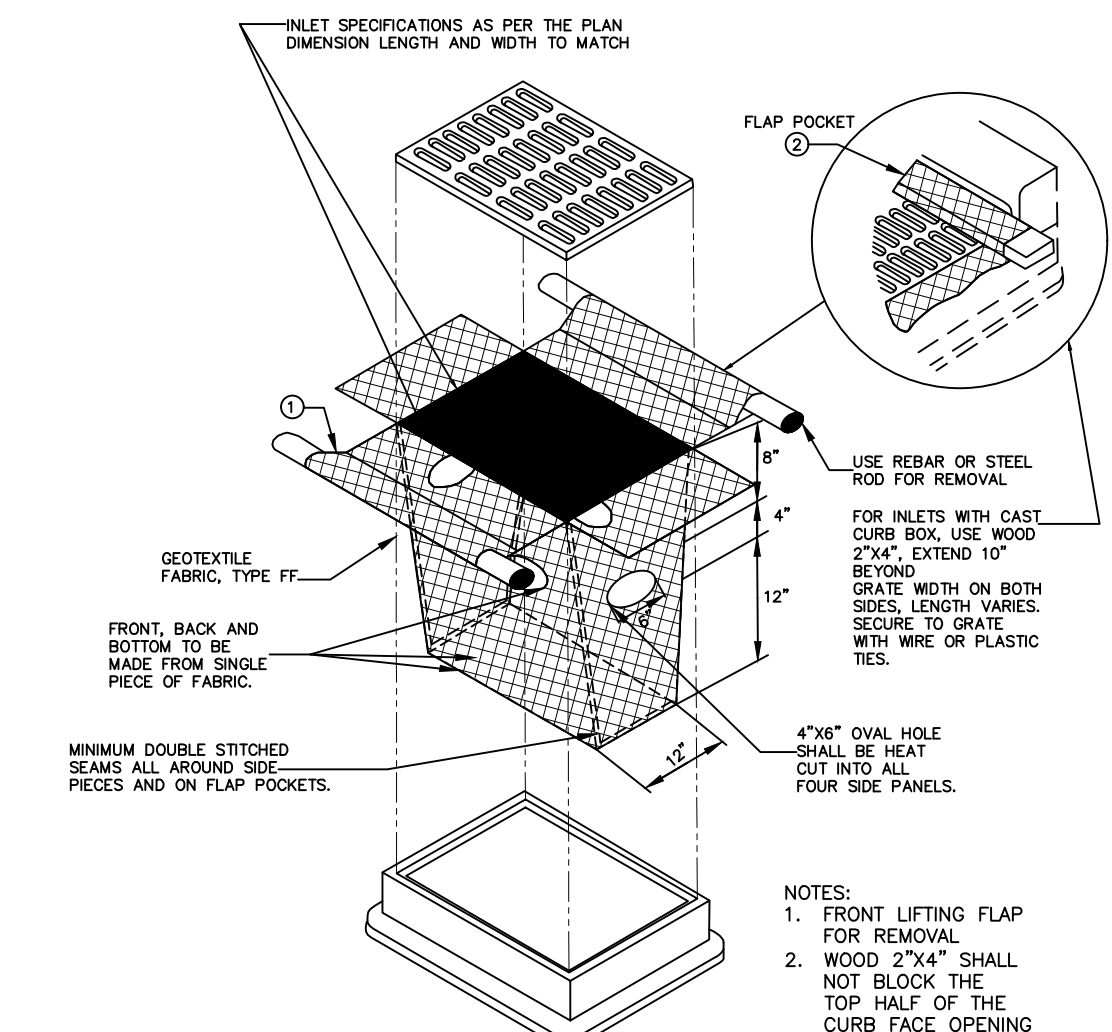


INLET PROTECTION

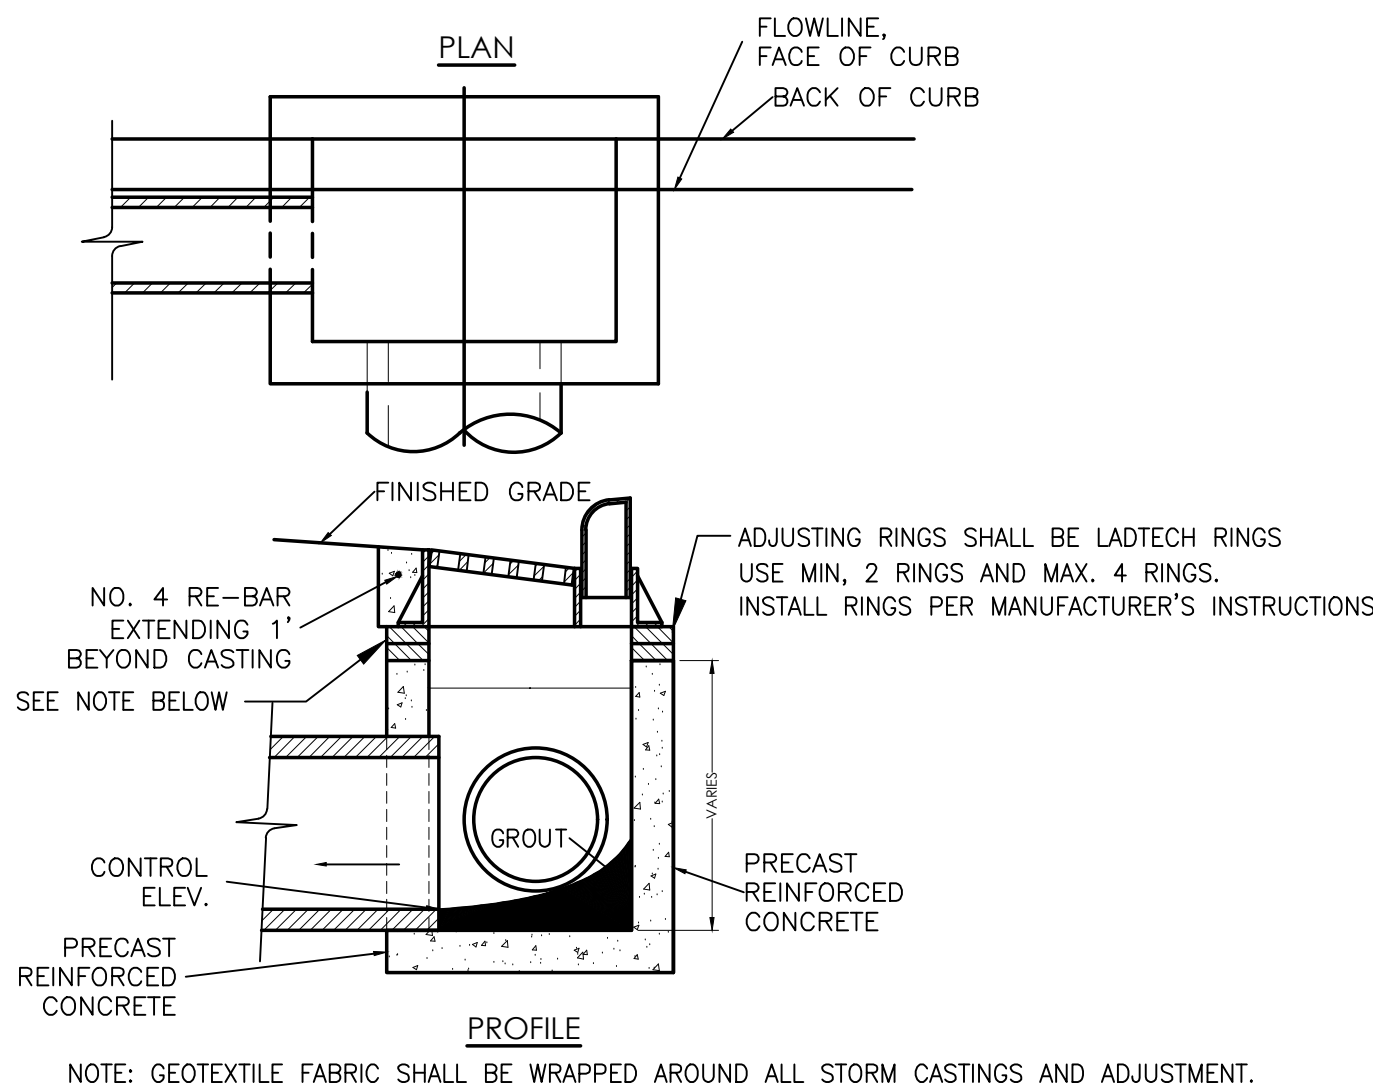


2'x3' BOX CATCH BASIN

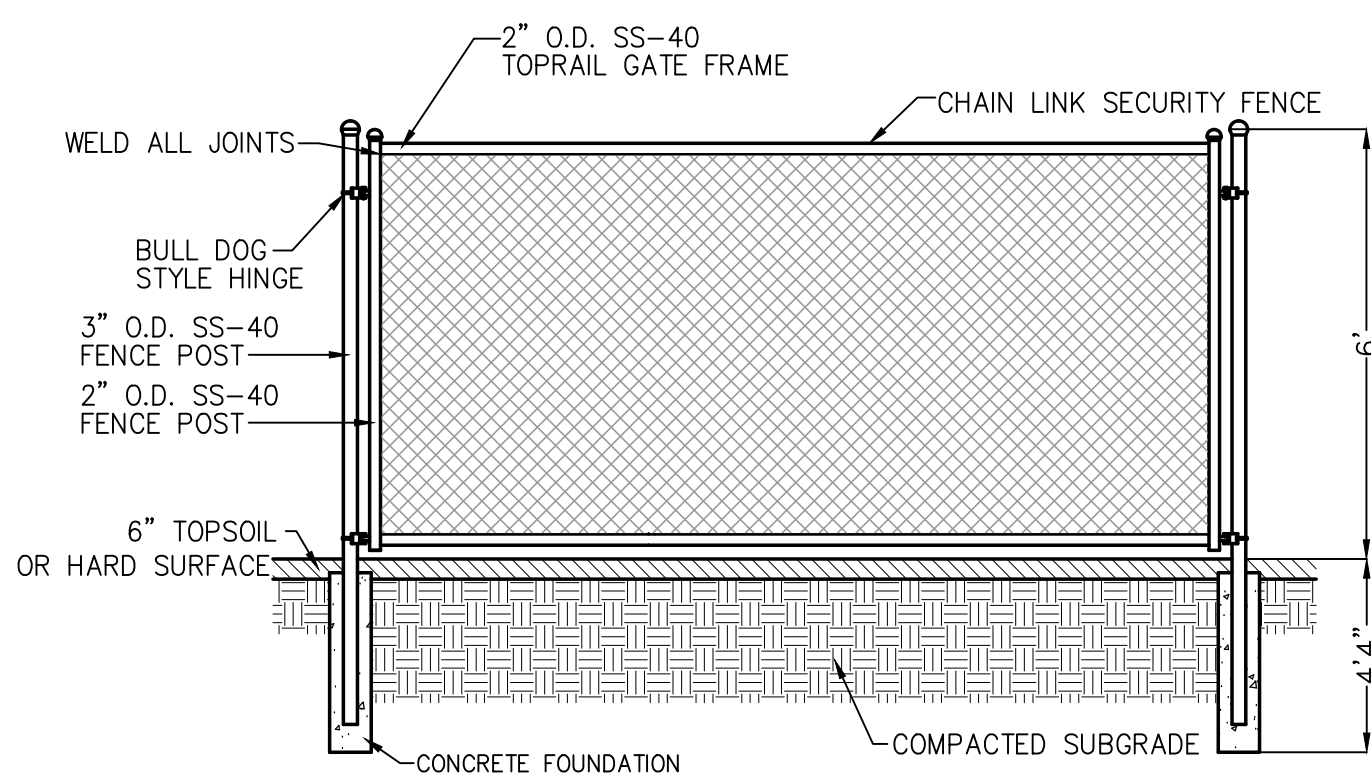


CHAIN LINK FENCE

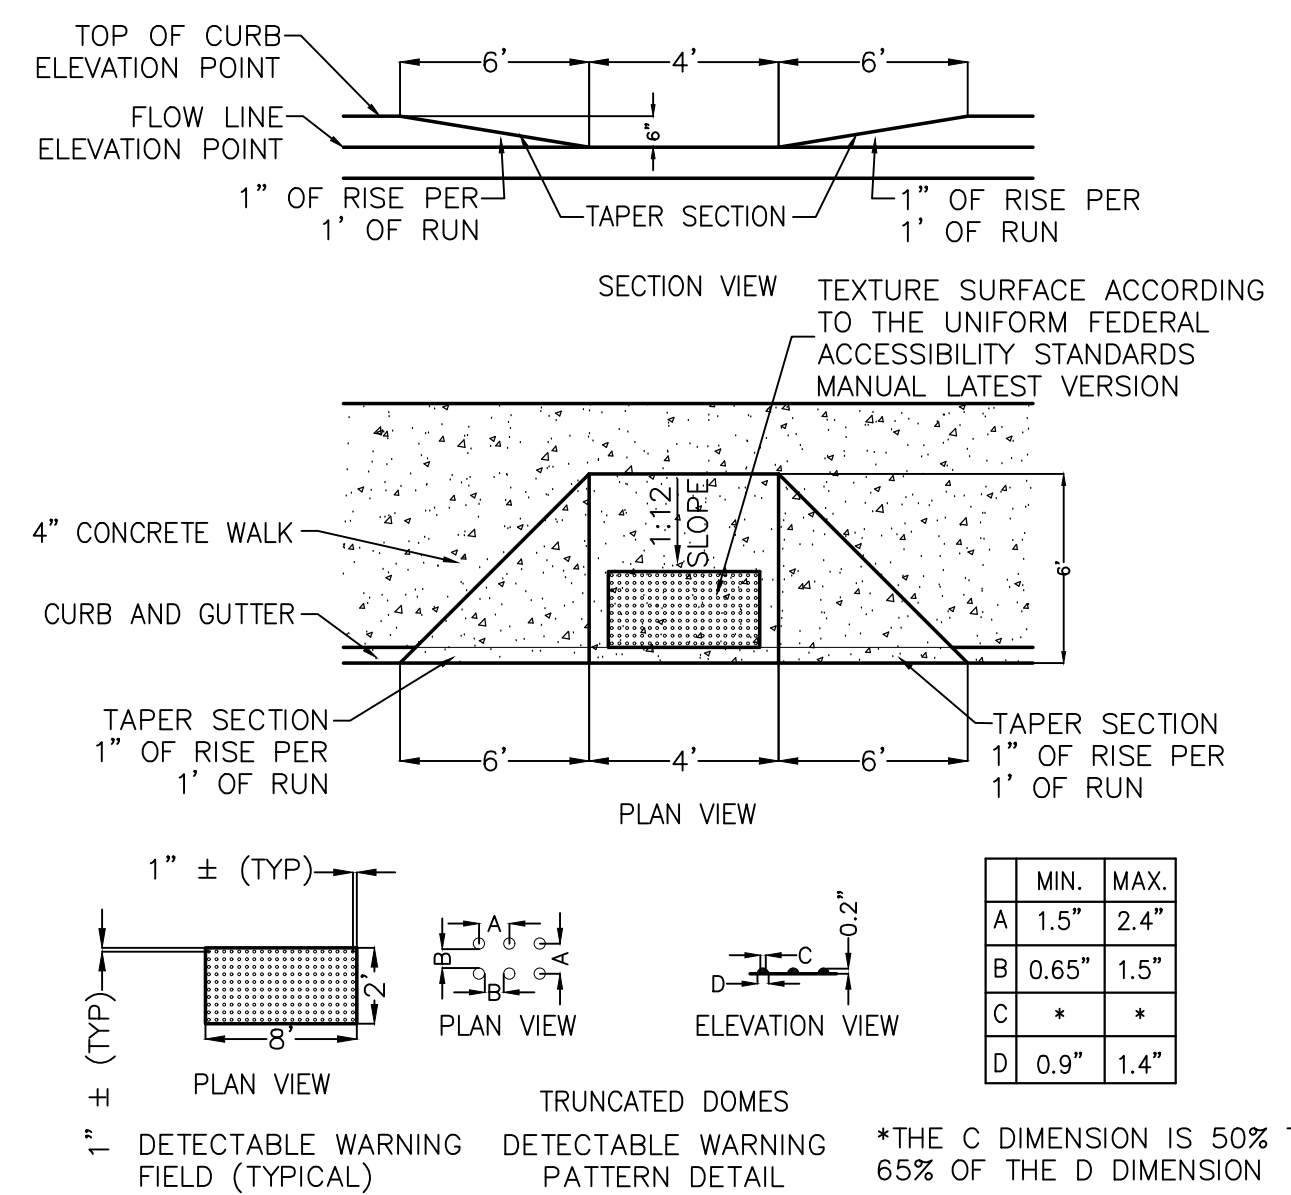


ADA CURB RAMP

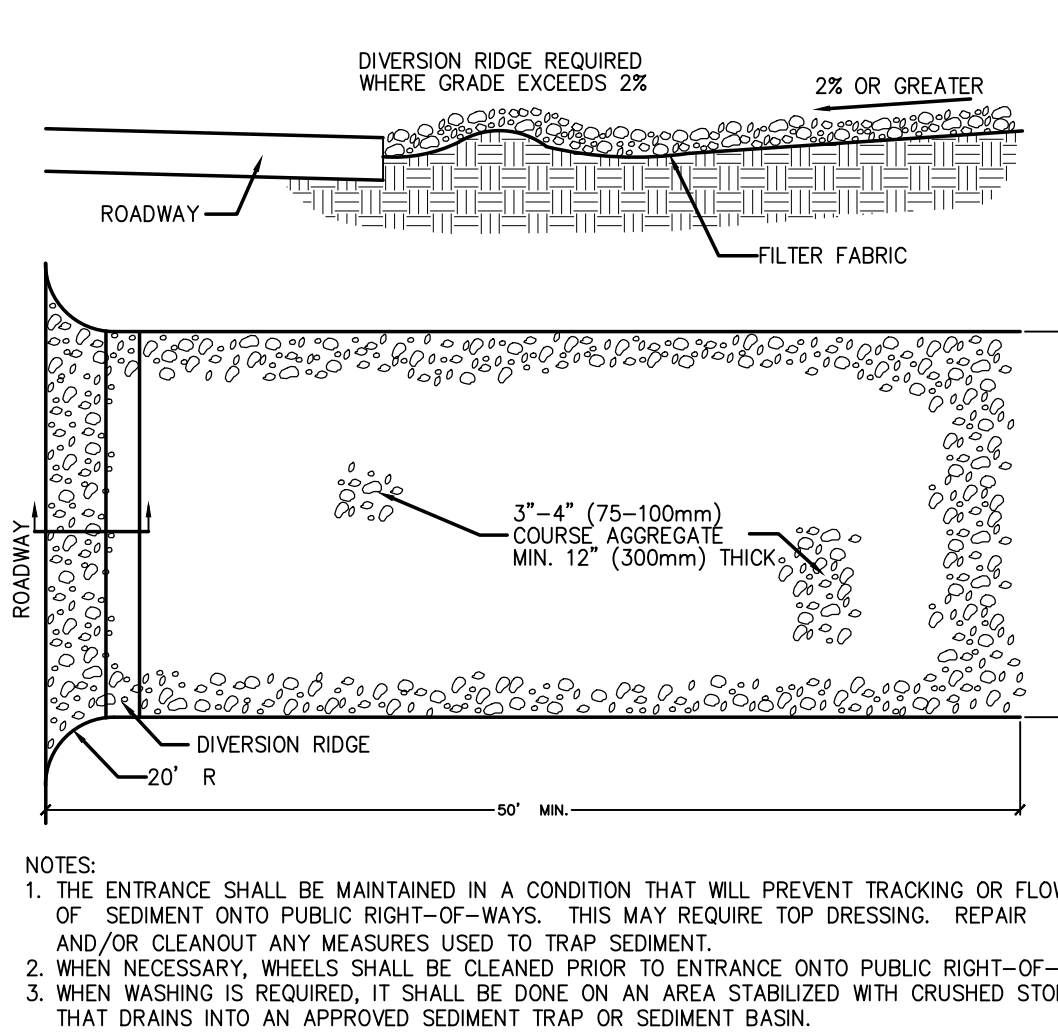


ROCK CONSTRUCTION ENTRANCE

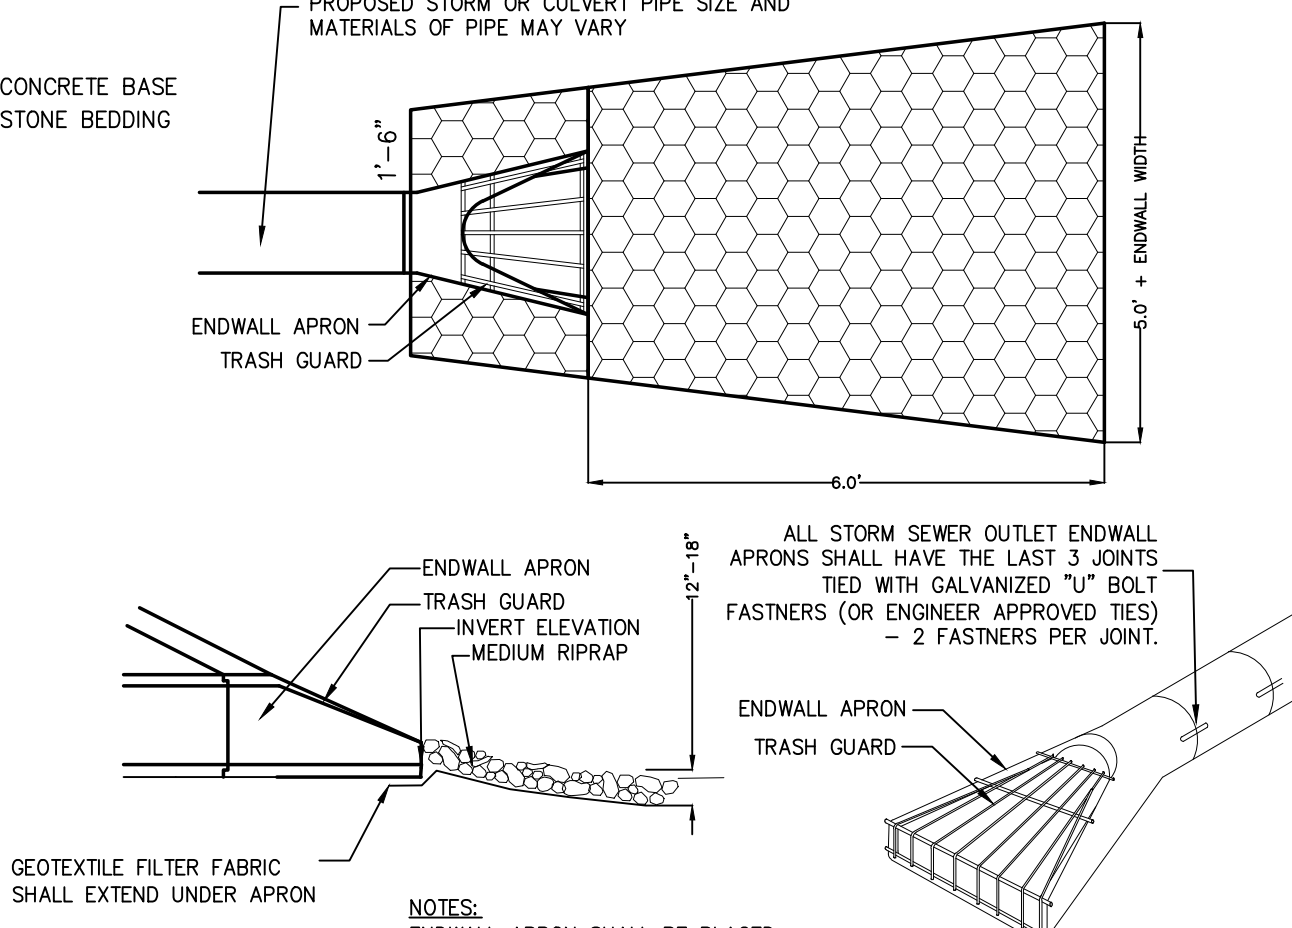


ENDWALL STRUCTURE

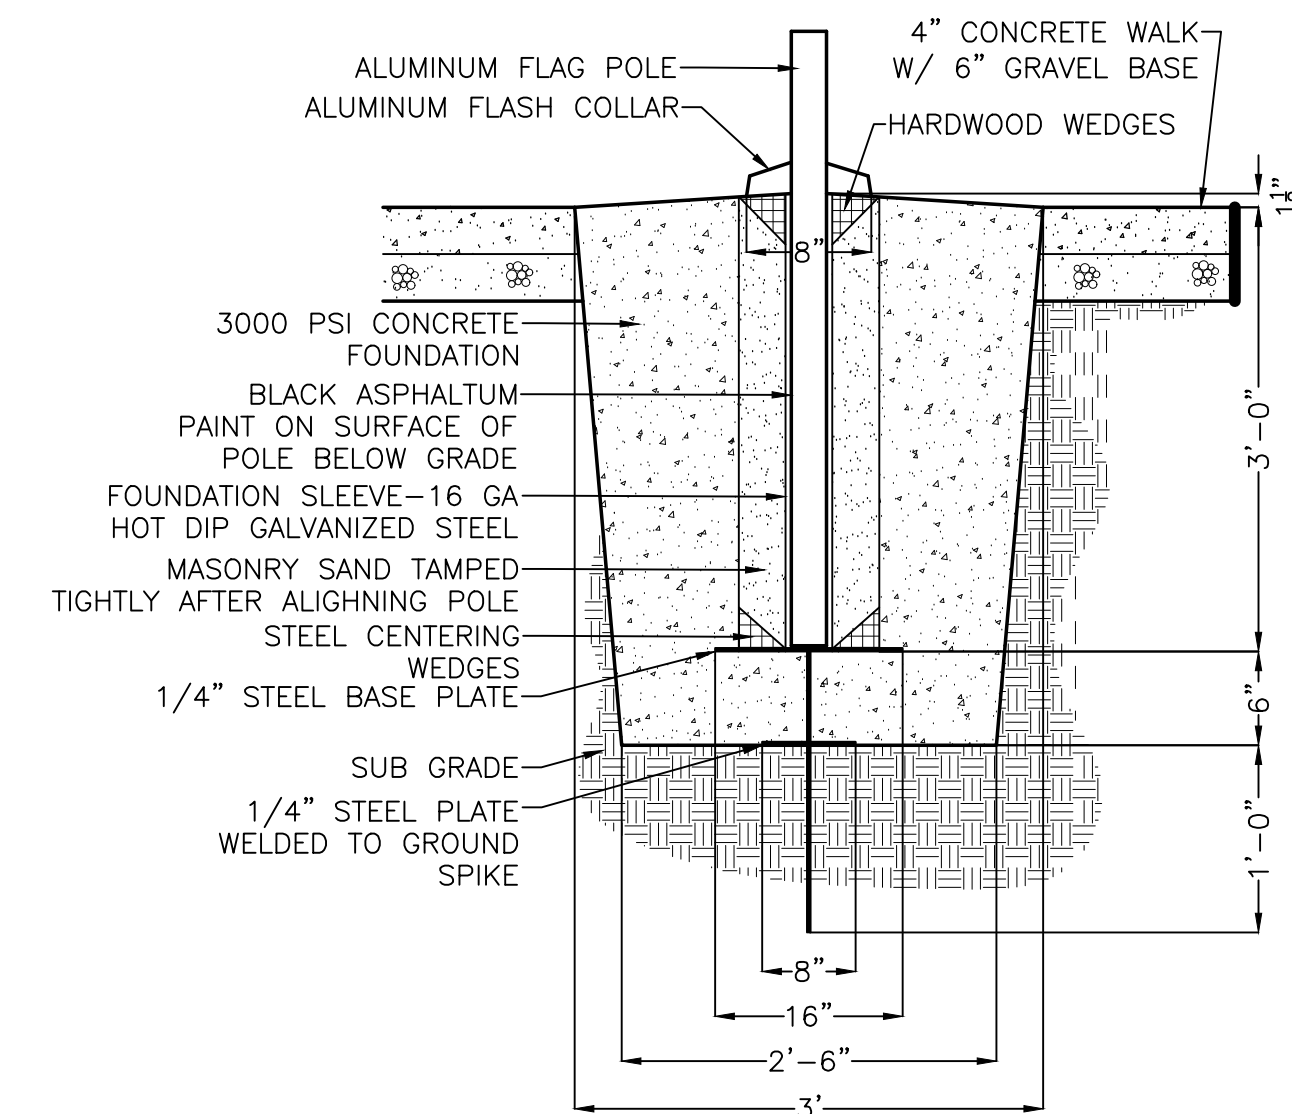


FLAG POLE BASE

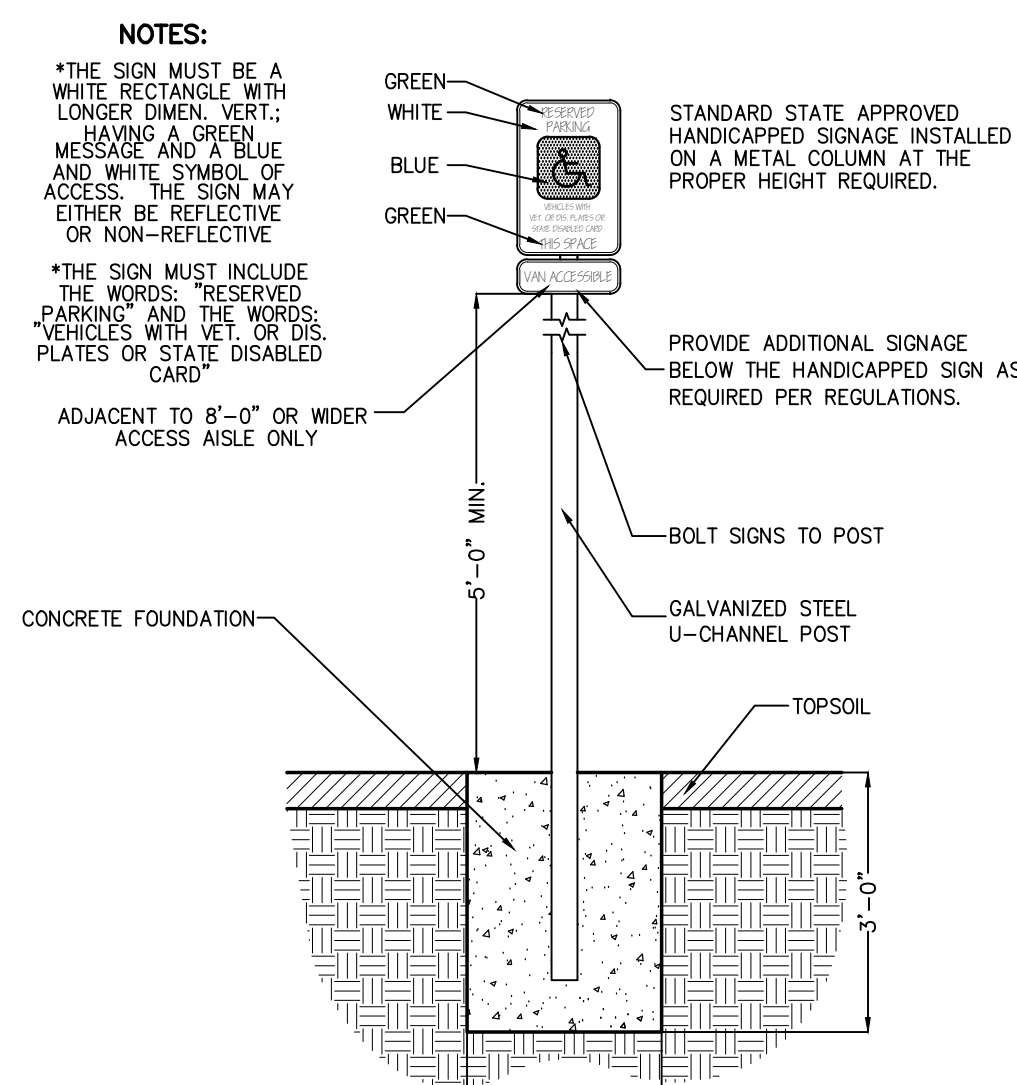


HANDICAP PARKING SIGN

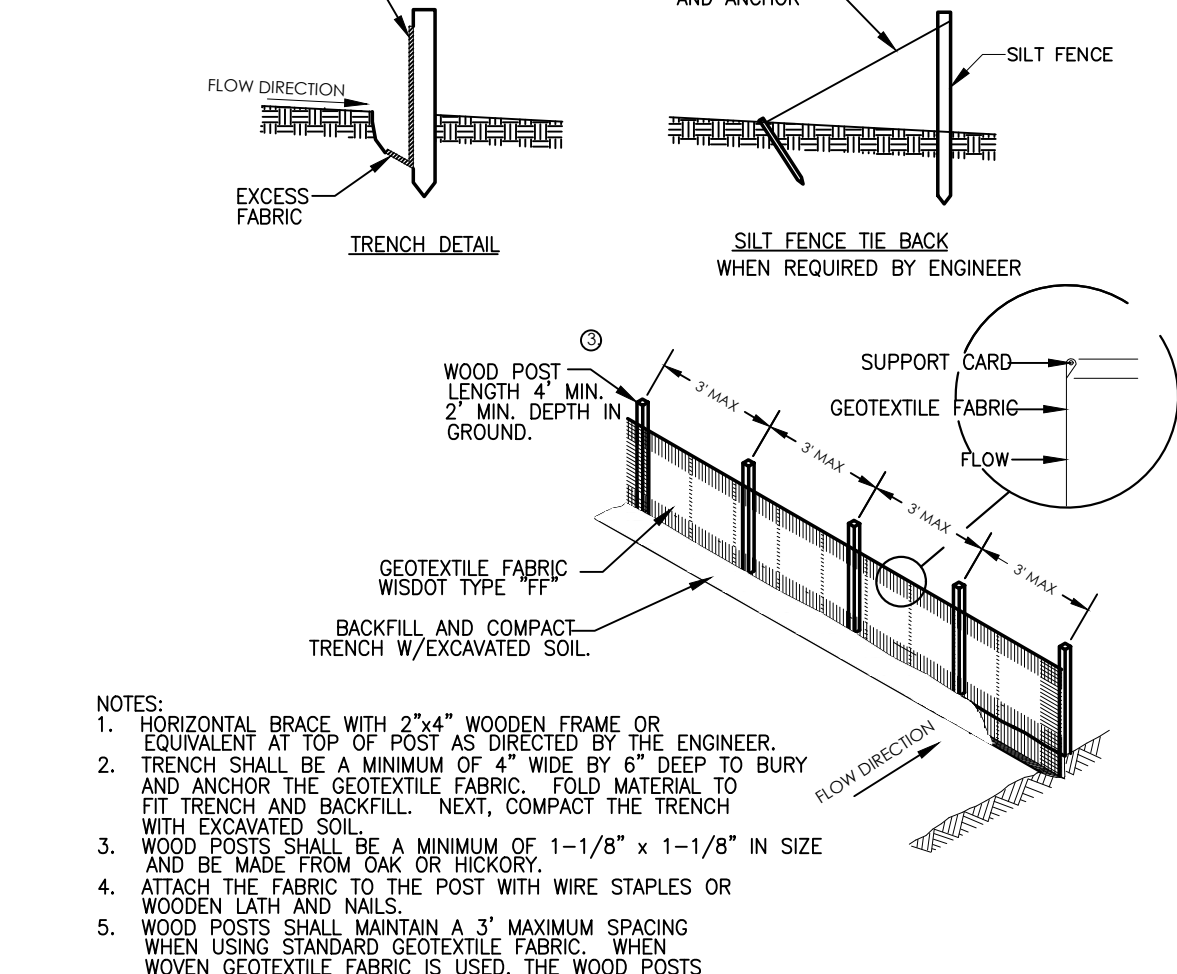


SILT FENCE

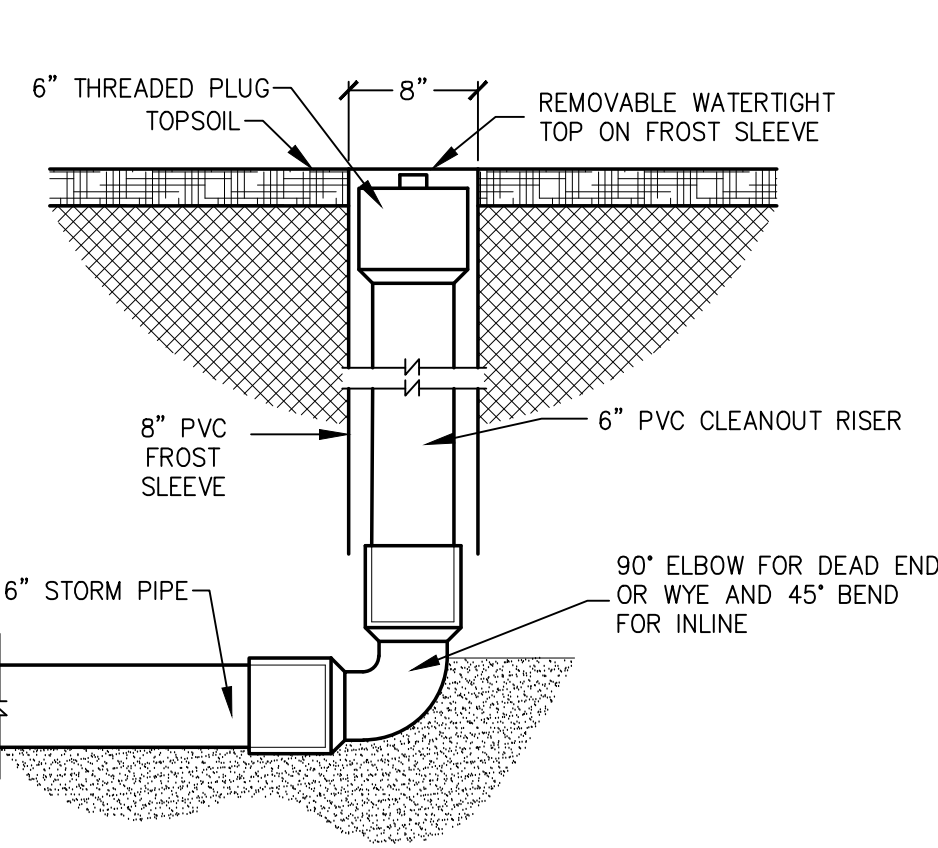


STORM SEWER CLEANOUT

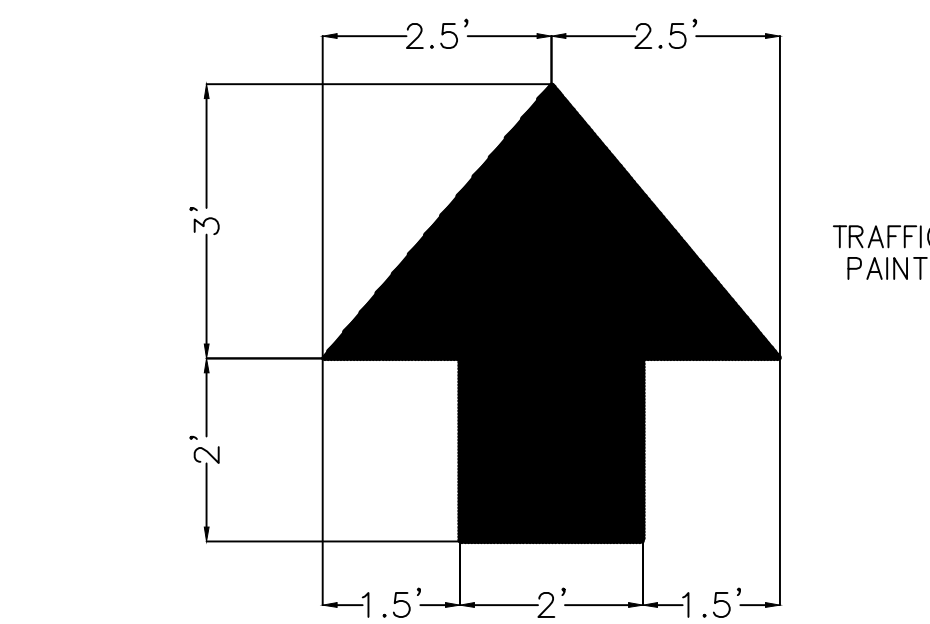


DIRECTIONAL ARROW

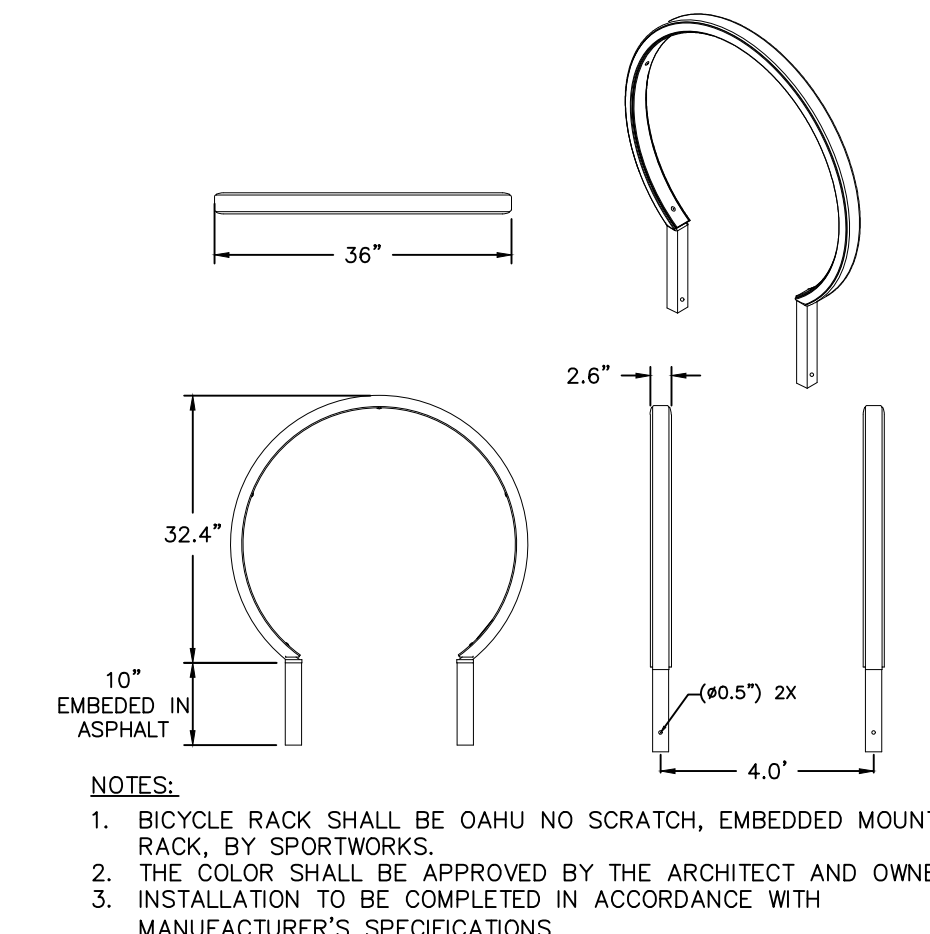

BIKE RACK

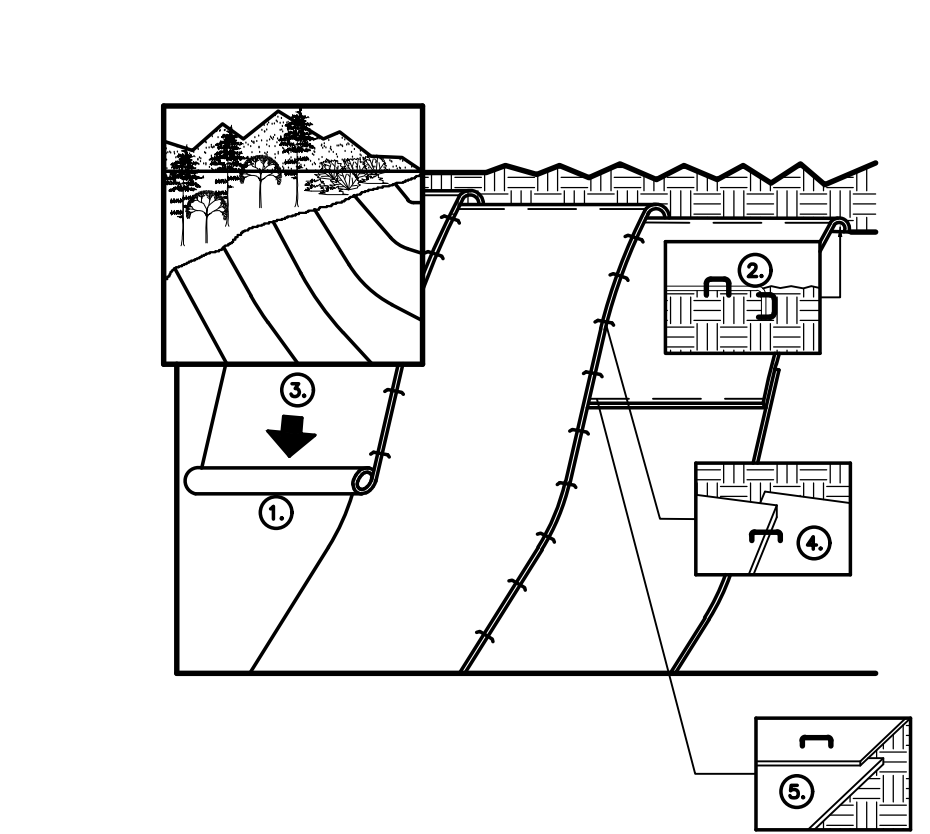

EROSION CONTROL BLANKETS

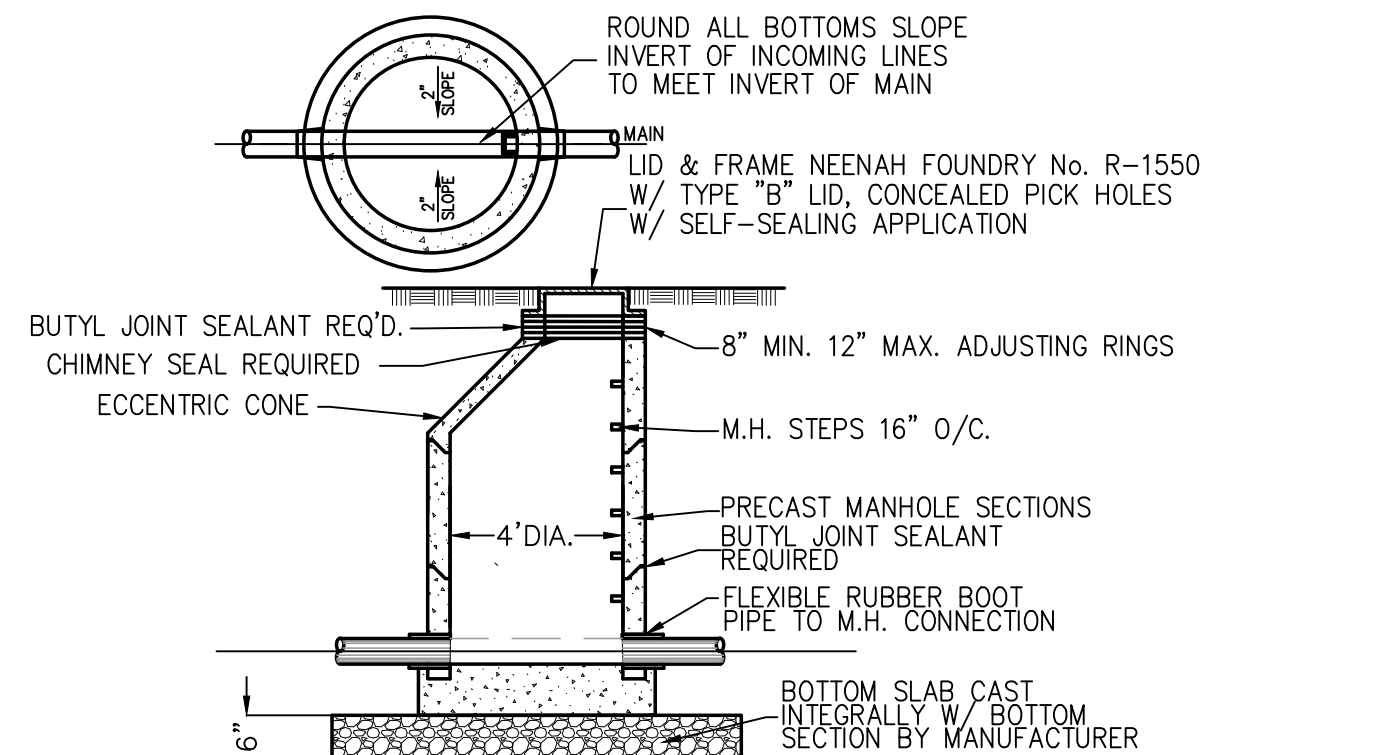

SANITARY MANHOLE




E

D

C

B

A

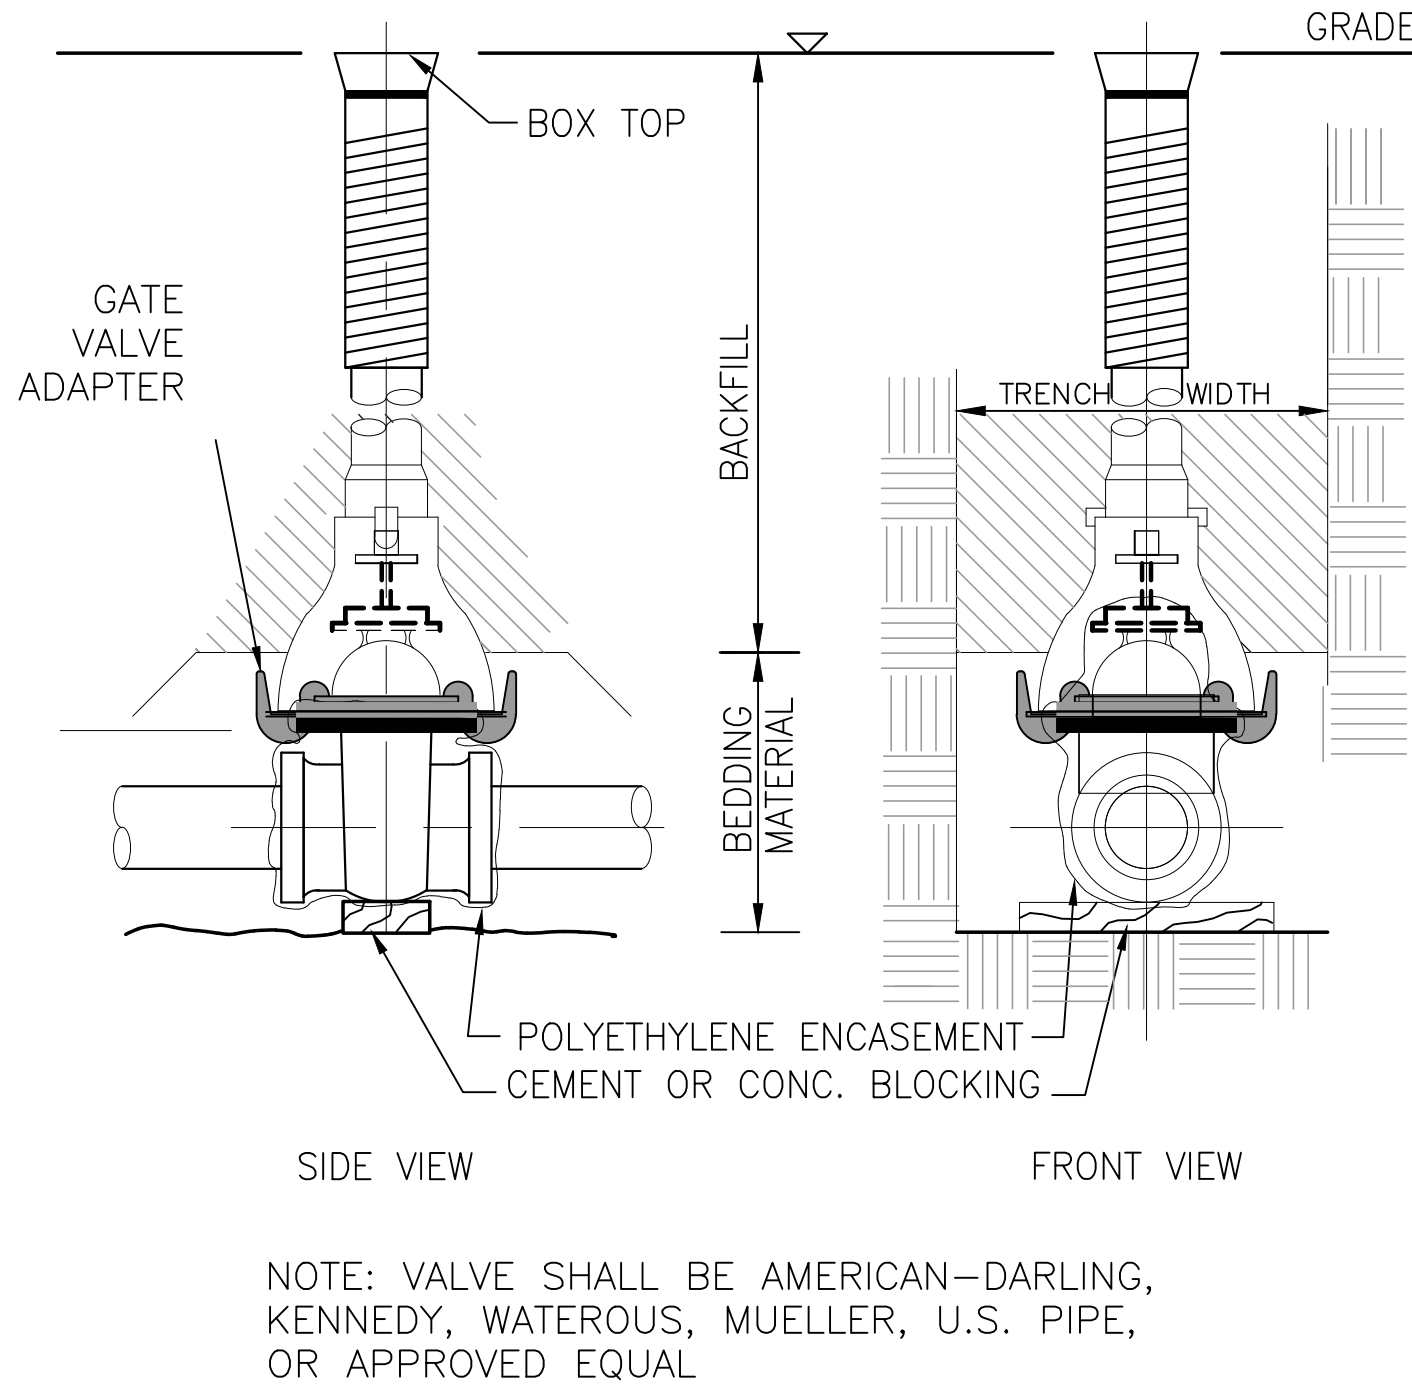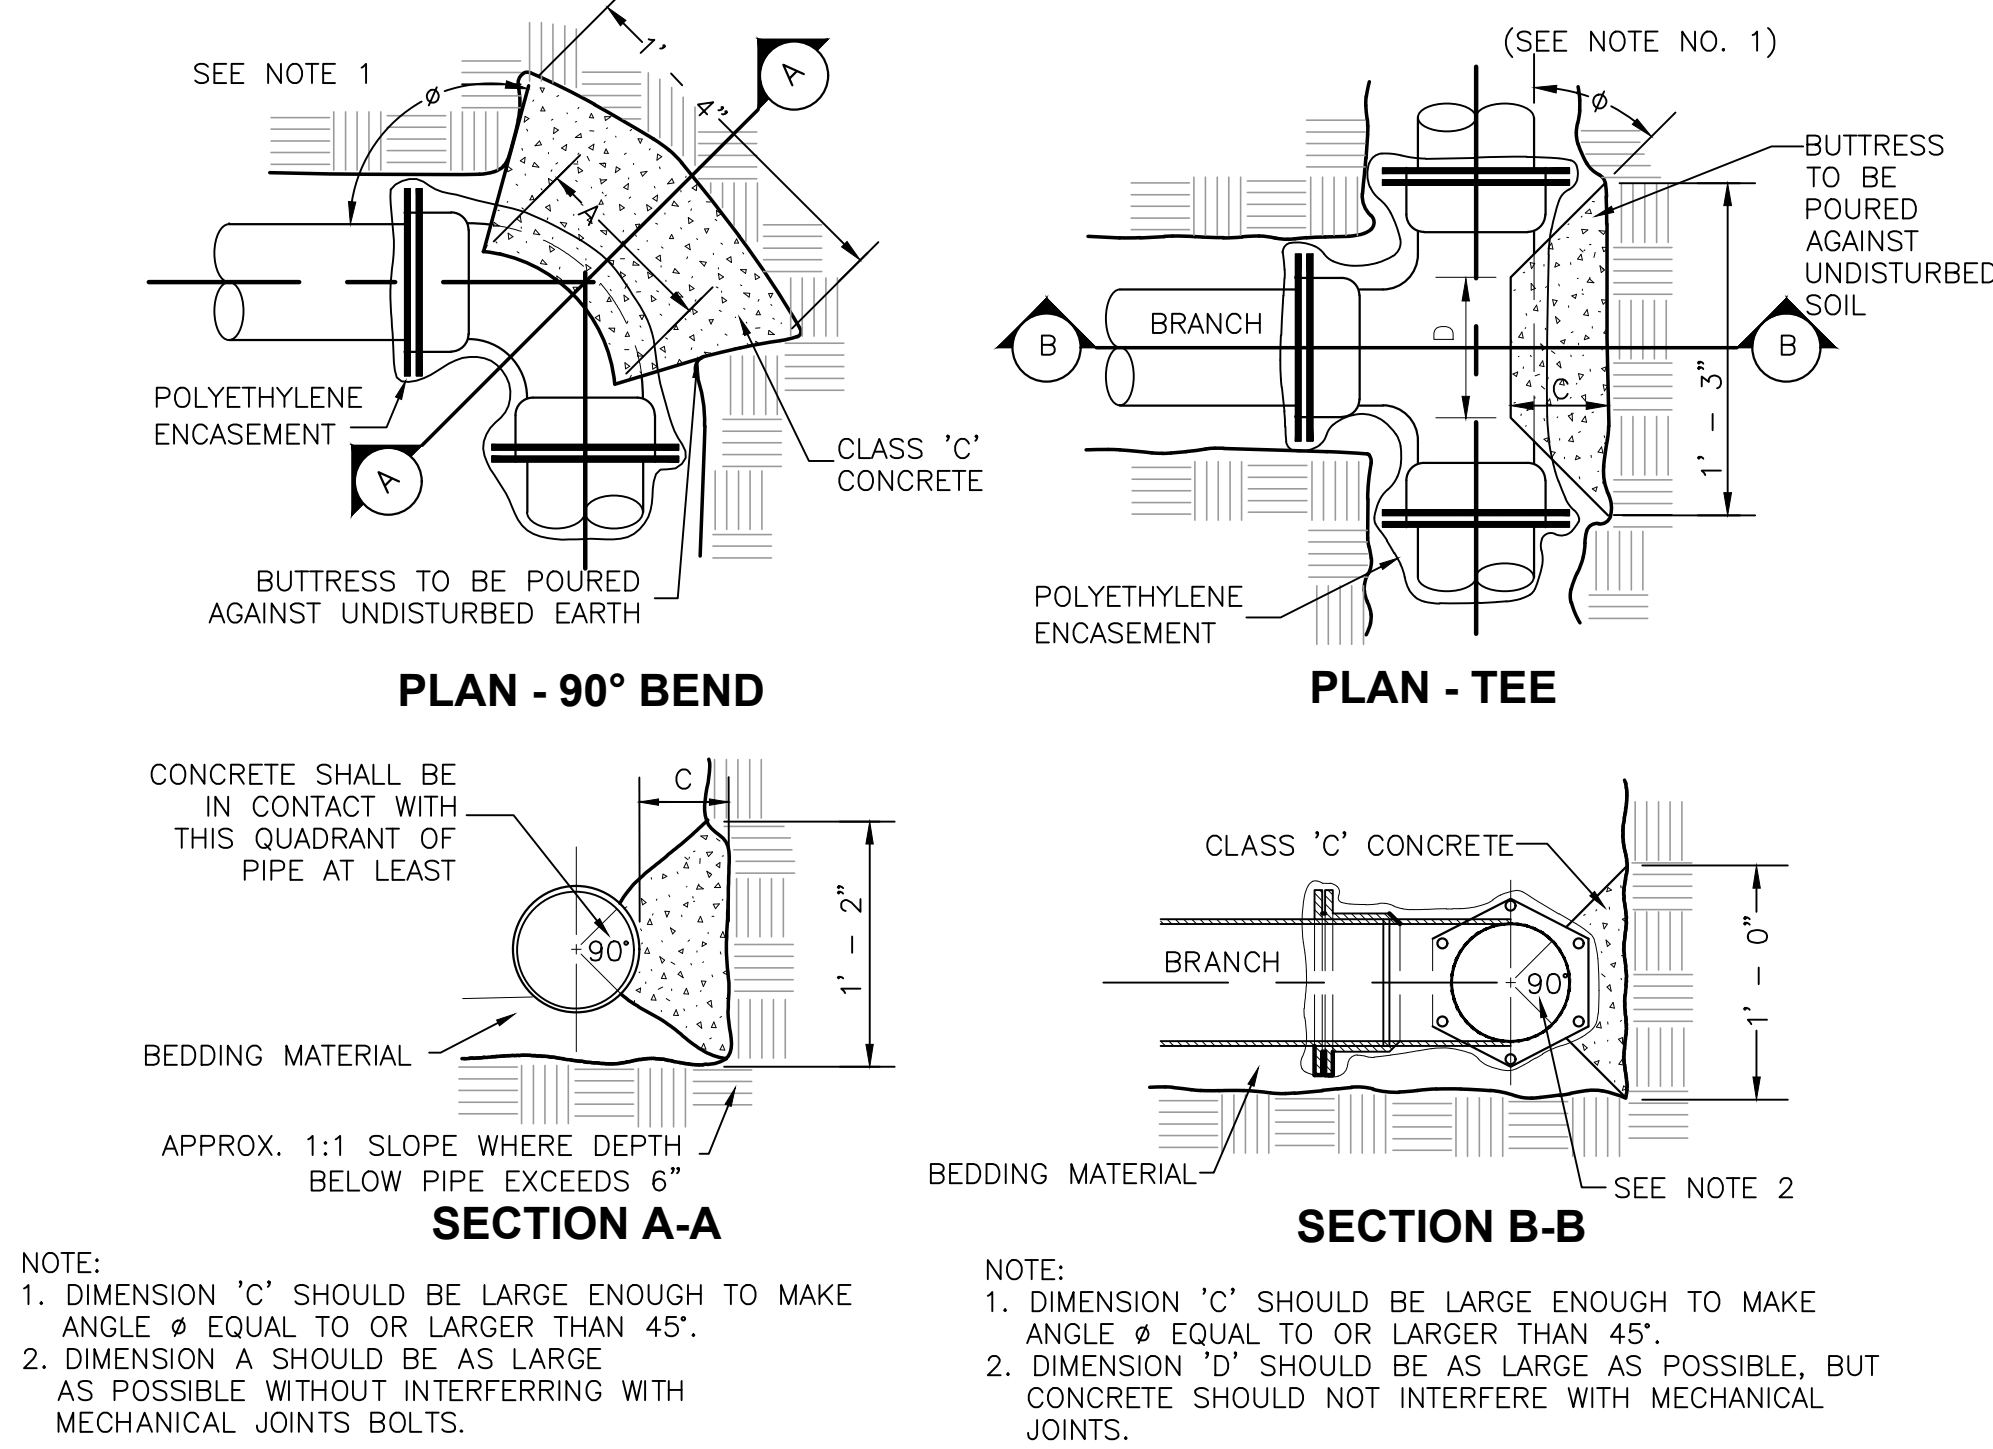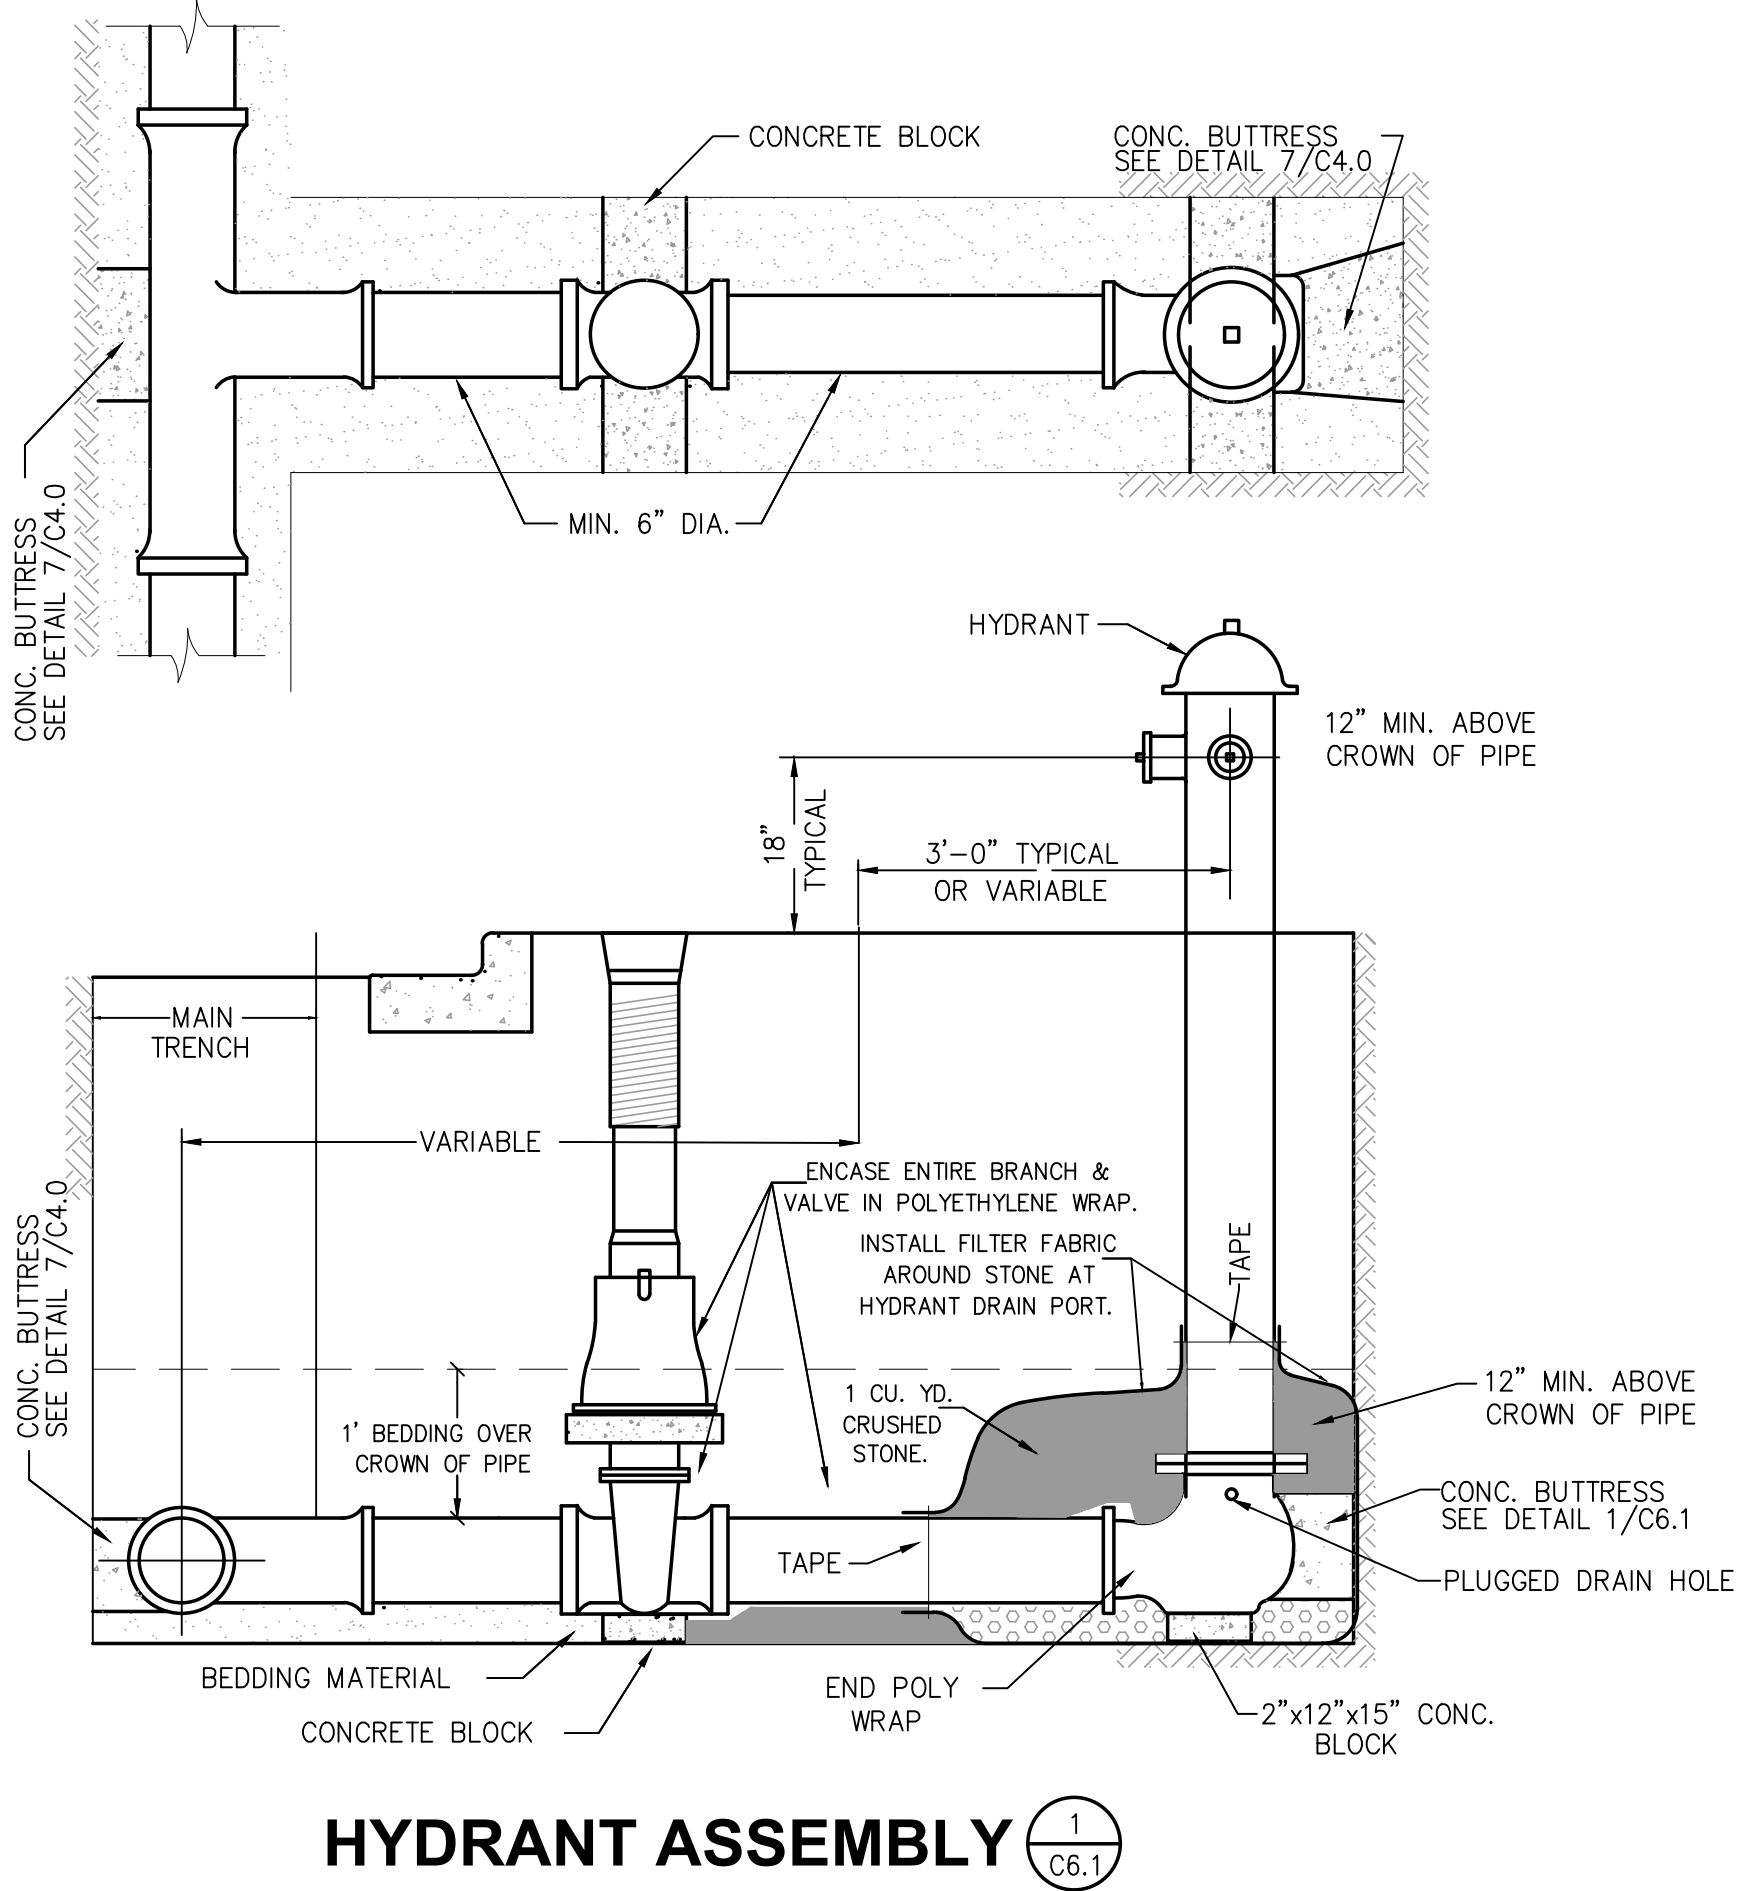



Plan View
Scale - 1" = 40'

Statistics						
Description	Symbol	Avg	Max	Min	Max/Min	Avg/Min
AREA OUTSIDE CALC ZONES	✕	0.1 fc	4.6 fc	0.0 fc	N/A	N/A
ISLAND	◇	2.0 fc	9.1 fc	0.2 fc	45.5:1	10.0:1
PARKING/DRIVE - BUS AREA	+	0.9 fc	2.8 fc	0.1 fc	28.0:1	9.0:1
PARKING/DRIVE - MIAN ENTRANCE	+	1.6 fc	9.6 fc	0.2 fc	48.0:1	8.0:1
WALKWAY - MAIN ENTRANCE	+	1.4 fc	4.7 fc	0.1 fc	47.0:1	14.0:1

Schedule						
Symbol	Label	Quantity	Manufacturer	Catalog Number	Description	Number Lamps
□ •	Y13	5	EATON - MCGRAW-EDISON (FORMER COOPER LIGHTING)	GLEON-AF-03-LED-E1-SL3	GALLEON AREA AND ROADWAY LUMINAIRE (3) 70 CRI, 4000K, 1050mA LIGHTSQUARES WITH 16 LEDES EACH AND TYPE III SPILL LIGHT ELIMINATOR OPTICS Retail, Roadway, Sidewalk, Site, Street, Substation, Security, Corrosion Resistant, Vandal Resistant, Wet Location ABSOLUTE PHOTOMETRY IS BASED ON CALIBRATION FACTORS CREATED USING LAB LUMEN STANDARDS IN GONIOPHOTOMETER WITH TEST DISTANCE OF 28.75 FEET	48
◇ •	Y14	1	EATON - MCGRAW-EDISON (FORMER COOPER LIGHTING)	GLEON-AF-03-LED-E1-SL4	GALLEON AREA AND ROADWAY LUMINAIRE (3) 70 CRI, 4000K, 1050mA LIGHTSQUARES WITH 16 LEDES EACH AND TYPE IV SPILL LIGHT ELIMINATOR OPTICS Retail, Roadway, Sidewalk, Site, Street, Substation, Security, Corrosion Resistant, Vandal Resistant, Wet Location ABSOLUTE PHOTOMETRY IS BASED ON CALIBRATION FACTORS CREATED USING LAB LUMEN STANDARDS IN GONIOPHOTOMETER WITH TEST DISTANCE OF 28.75 FEET	48
□ •	Y23	4	EATON - MCGRAW-EDISON (FORMER COOPER LIGHTING)	GLEON-AF-03-LED-E1-SL3	GALLEON AREA AND ROADWAY LUMINAIRE (3) 70 CRI, 4000K, 1050mA LIGHTSQUARES WITH 16 LEDES EACH AND TYPE III SPILL LIGHT ELIMINATOR OPTICS Retail, Roadway, Sidewalk, Site, Street, Substation, Security, Corrosion Resistant, Vandal Resistant, Wet Location ABSOLUTE PHOTOMETRY IS BASED ON CALIBRATION FACTORS CREATED USING LAB LUMEN STANDARDS IN GONIOPHOTOMETER WITH TEST DISTANCE OF 28.75 FEET	48
					Filesname	Lumens Per Lamp
					GLEON-AF-03-LED-E1-SL3.ies	378
					Light Loss Factor	Wattage
					0.9	166
					360	166
					0.9	332

